 
 
 
 
 
 
 

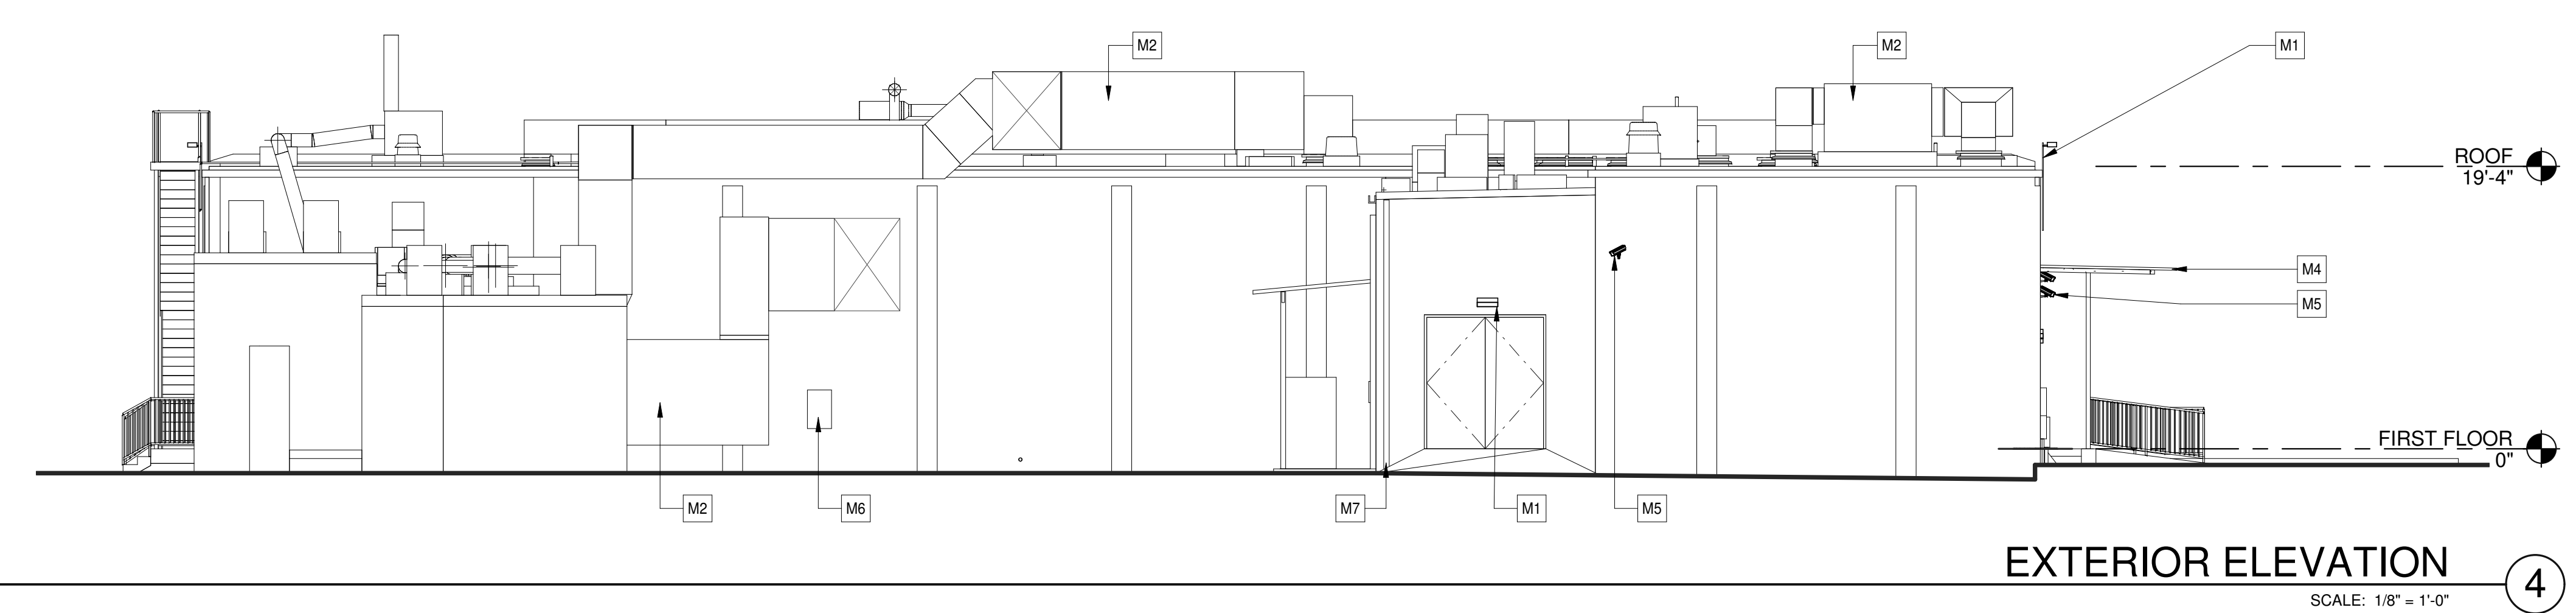
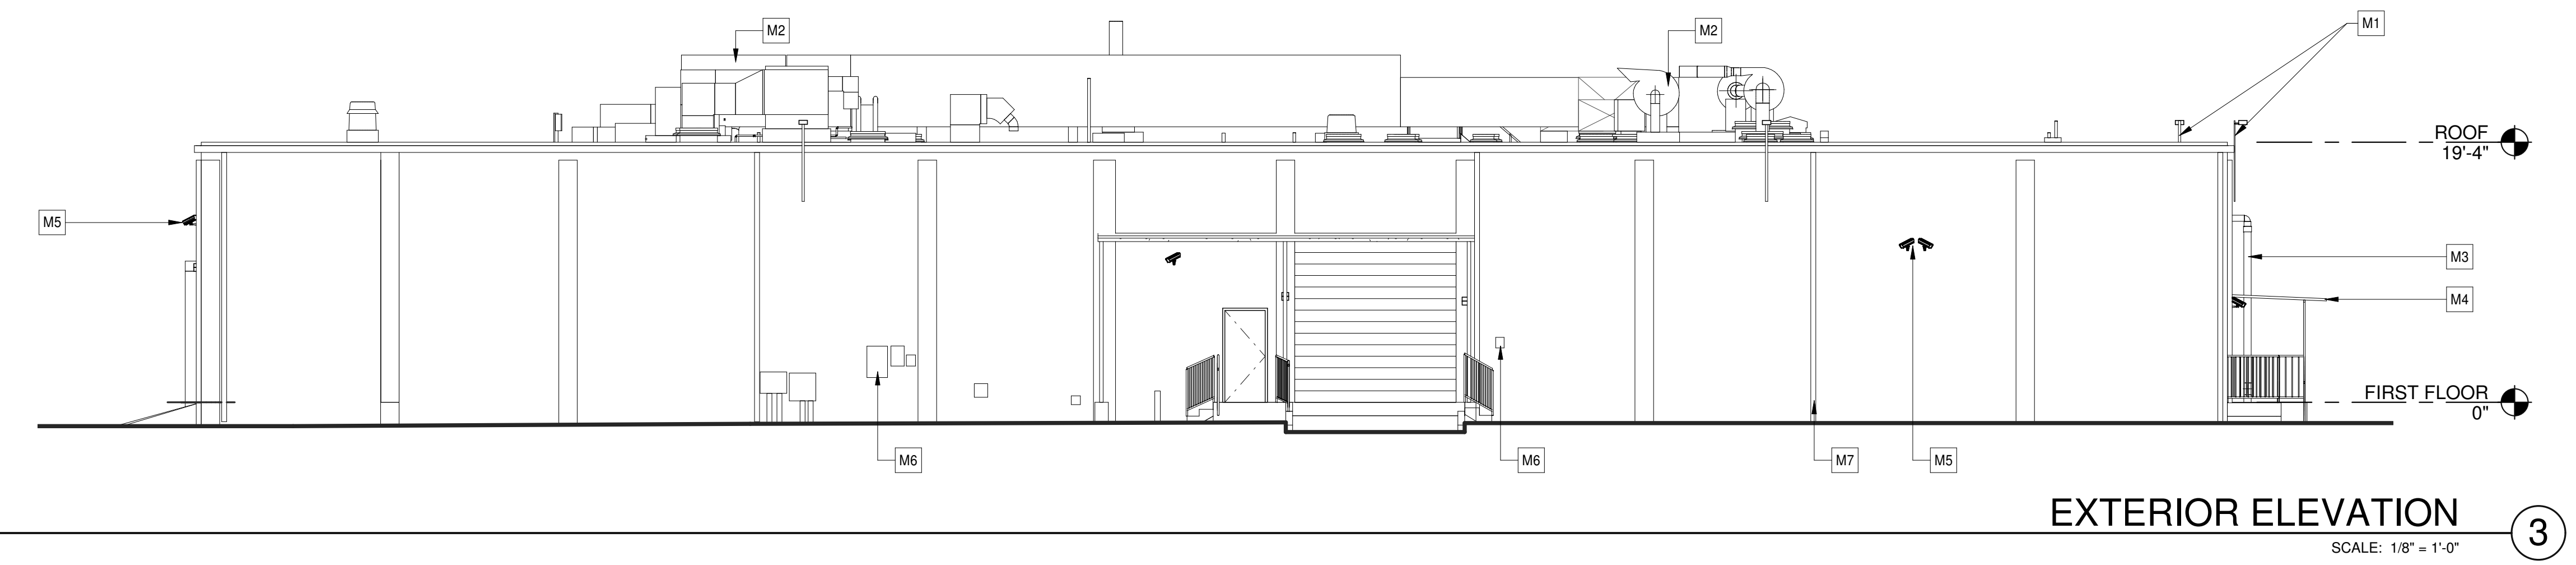


KEYNOTES: 
SEE SHEET A010 FOR GENERAL NOTES


WARE MALCOMB
ARCHITECTURE
PLANNING
INTERIORS
1000 Redlands
Irvine, CA 92618
P 949.660.0128

LEGEND

-  M1 LIGHTS
-  M2 DUCTS (TYP)
-  M3 PIPES (TYP)
-  M4 CANOPY
-  M5 CAMERA (TYP)
-  M6 ELECTRICAL PANELS (TYP)
-  M7 RAIN DROP PIPE

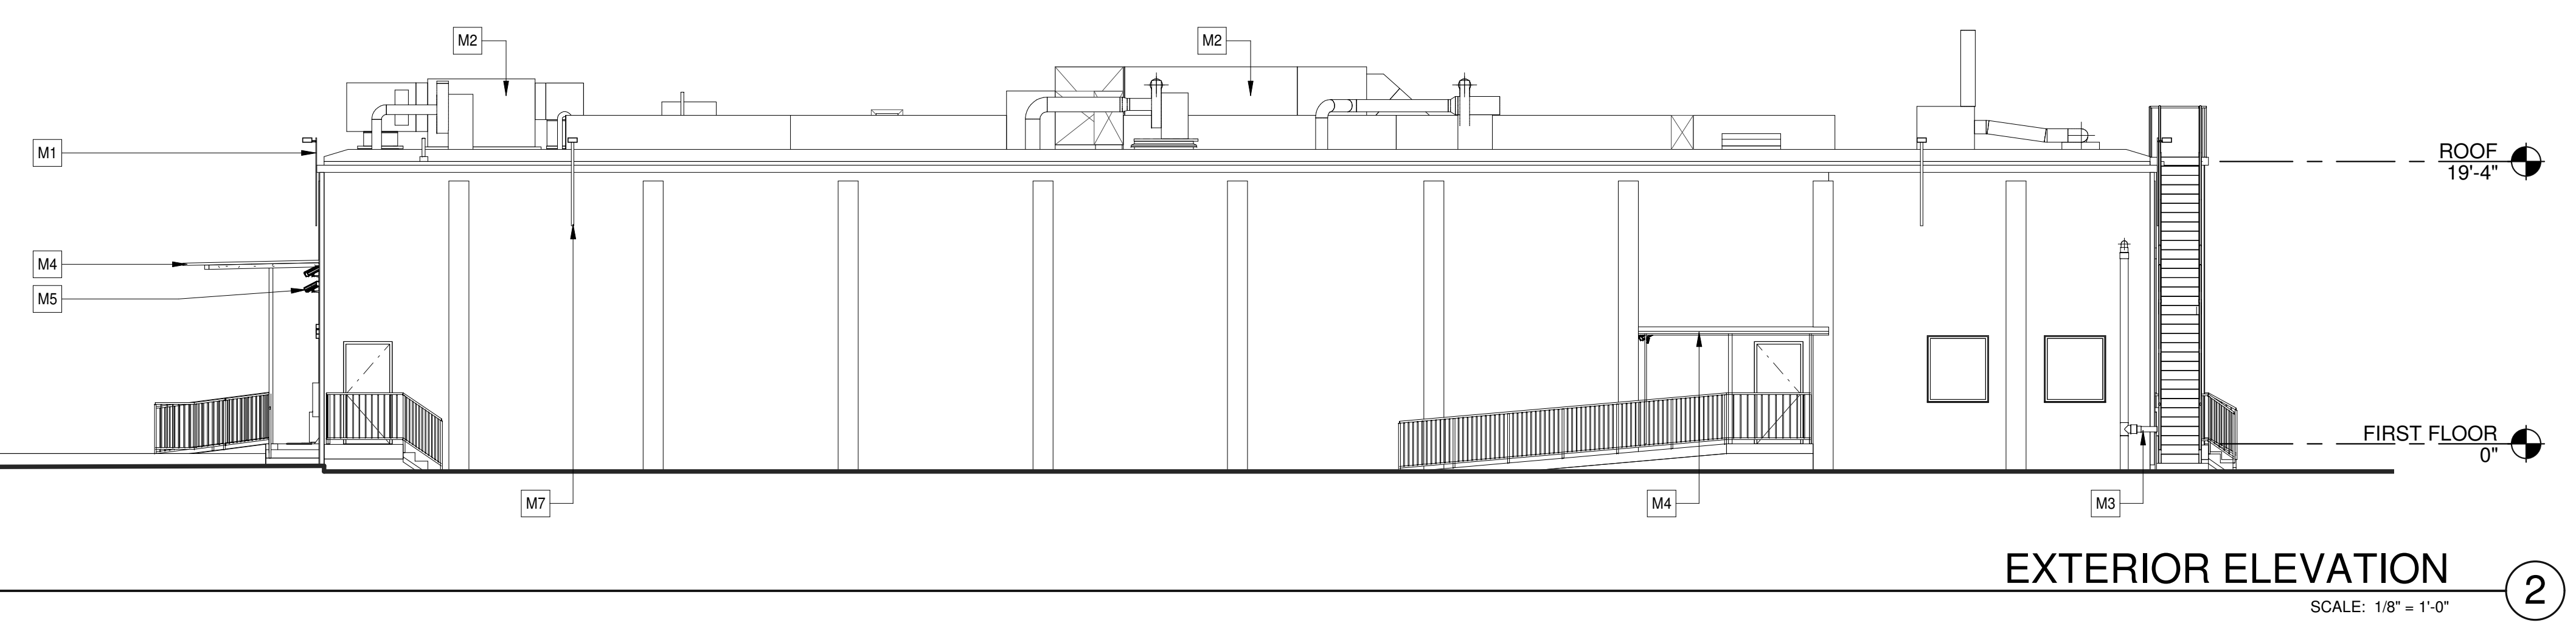

KEY PLAN

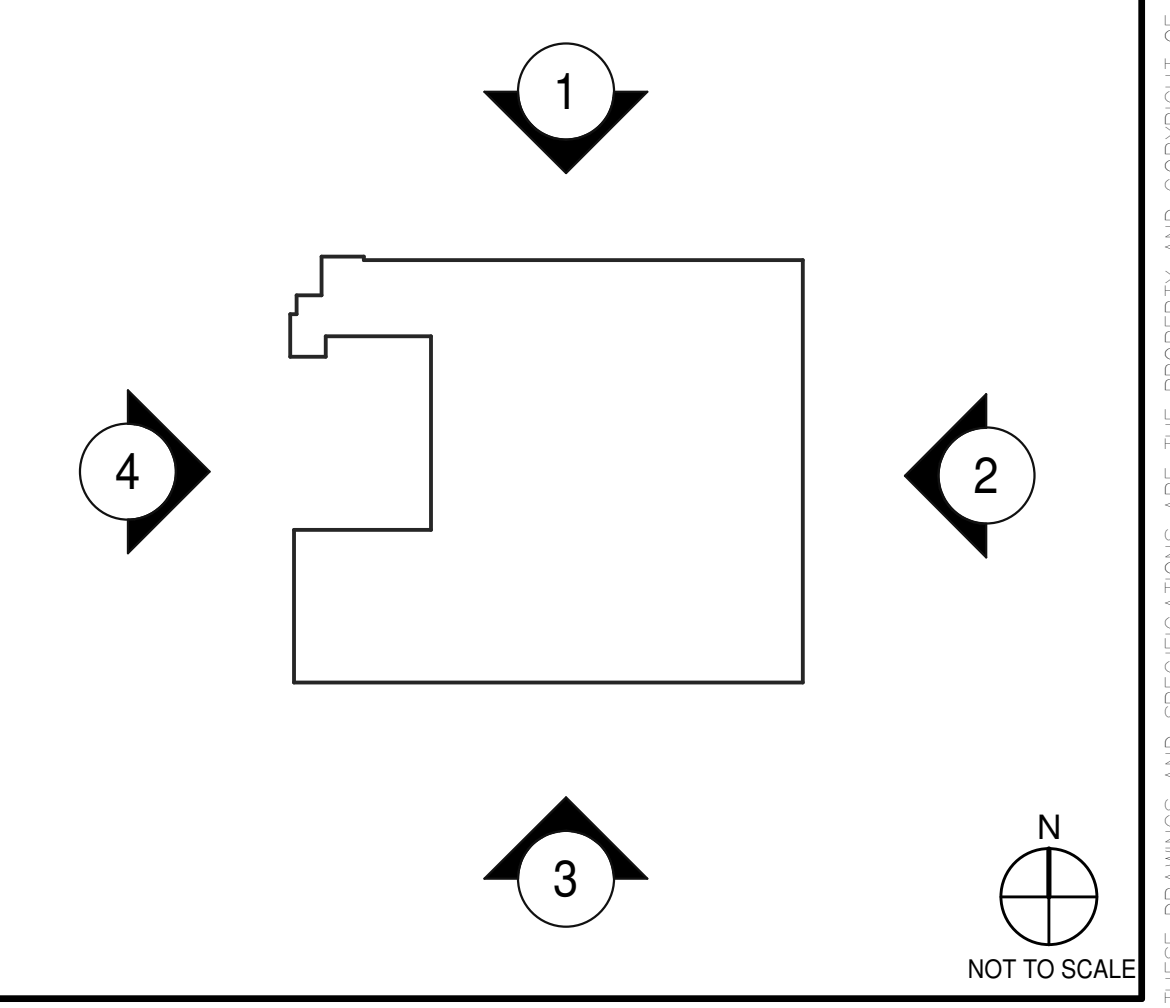

EXTERIOR ELEVATIONS	
DATE	REMARKS

PA/PM: REI TAKATA
DRAWN BY: RUSSEL INGRAM
JOB NO.: WDC23-5030-00

SHEET
B210
11/29/2023 8:54:31 PM
2/23/2024 8:54:31 PM
PROGRESS CHECK