

ABBREVIATIONS


SYMBOLS

PROJECT SCOPE

SURVEYOR

SHEET INDEX

Table of abbreviations with columns for symbol, description, and material/finish name. Includes entries like & (And), A.D. (Area Drain), ACQUIS (Acoustical), etc.

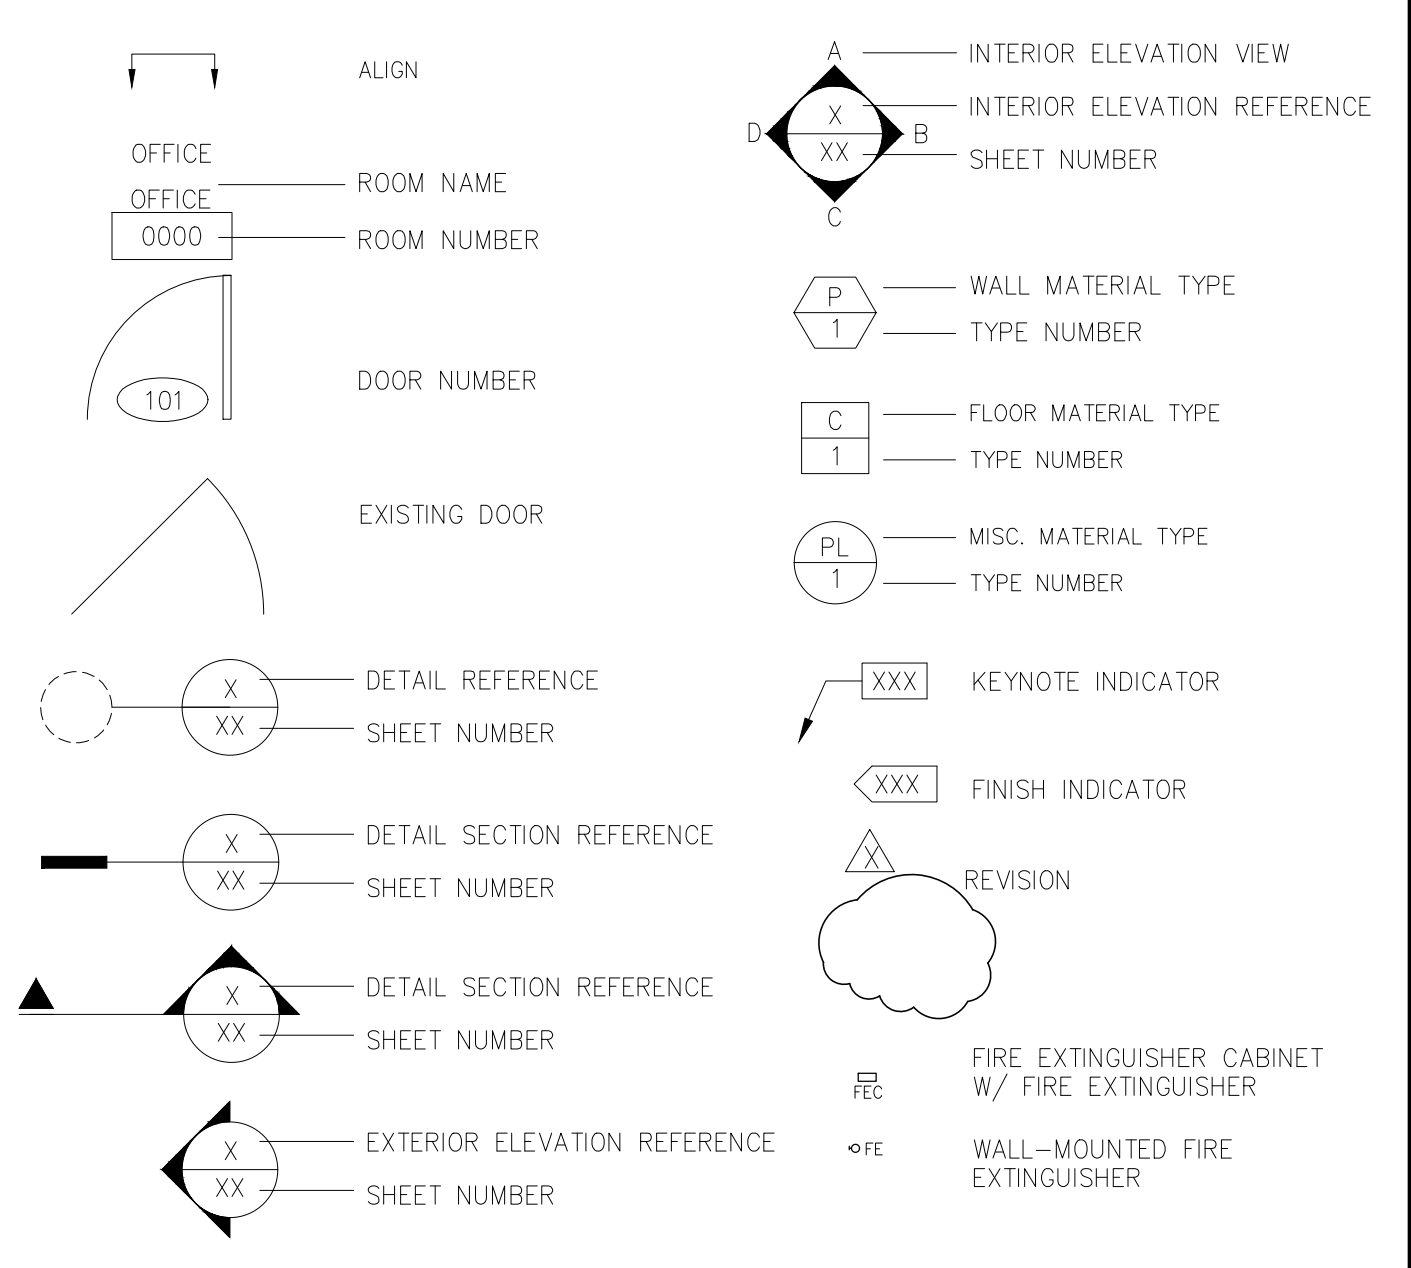

- TIER I
• LOCATION OF INTERIOR/EXTERIOR WALLS, DOORS
• LOCATION OF INTERIOR WINDOWS
• LOCATION OF EXTERIOR WINDOWS
• LOCATION OF VISIBLE INTERIOR COLUMNS
• LOCATION OF PERMANENT CABINETS (I.E. KITCHENS, VANITIES, ETC.)
• LOCATION OF STAIRS
• LOCATION AND CAB SIZE OF ELEVATORS
• TYPICAL CEILING HEIGHTS
• VOLTAGE, PHASING
• LOCATION OF ELECTRICAL PANELS (GENERAL LOCATION) - PANEL INFORMATION (AMPS, VOLTAGE, PHASING)
• PLUMBING FIXTURES (GENERAL LOCATION) - TOILETS, URINALS, STALLS, SINKS, WATER HEATERS, MOP SINKS, FIRE RISERS
• STANDARD PHOTOS - ALL AREAS INTERIOR AND EXTERIOR
• 360 PHOTOS - ALL AREAS INTERIOR AND EXTERIOR
- TIER II
• INTERIOR CEILING ELEMENTS (RCP - REFLECTED CEILING PLAN) - VISIBLE LIGHTS, DIFFUSERS, SPRINKLER HEADS, EXIST SIGNS, SMOKE DETECTORS, LOW VOLTAGE (IF KNOWN) - HEIGHTS OF STRUCTURAL ELEMENTS
• LOCATION OF INTERIOR ELECTRICAL - OUTLETS, SWITCHES, PLATES, DATA, TELEPHONE
• WINDOW SILL HEIGHTS
• WINDOW HEAD HEIGHTS (IF ACCESSIBLE)
• DOOR HEIGHTS

WARE MALCOMB
10 EDELMAN
IRVINE, CALIFORNIA 92618
P 949.660.9128
PRIMARY CONTACT: WAYNE BASTRUP
PH: 310.903.4000 x1210
EMAIL: wbastrup@waremalcomb.com
ALTERNATE CONTACT: EDDIE PORTILLO
PH: 310.903.4000 x1983
EMAIL: eportillo@waremalcomb.com

BMS-FIELD VERIFICATIONS SHEET LIST
Table with columns for sheet number and description. Includes B001 (TITLE SHEET), B110 (THIRD FLOOR PLAN - DIMENSIONED), B111 (THIRD FLOOR PLAN - NON DIMENSIONED), etc.

VICINITY MAP



Table with columns for DATE, REMARKS, and DATE. Intended for tracking field verifications.

DRAWING NOTES


THE DRAWINGS PRESENTED IN THIS SET ARE A REPRESENTATION OF EXISTING PROPERTY THAT IS GENERALLY ACCEPTED TO BE SUITABLE FOR USE IN PLANNING, DESIGN, LEASE AND GENERAL ASSET MANAGEMENT. IT SHOULD NOT BE USED TO DETERMINE EXACT LOCATIONS OF BUILDING ELEMENTS, STRUCTURAL COMPONENTS, SPACES OR OBJECTS, HEREIN FOR ANY PURPOSE. ALL OBJECTS SHOWN, INCLUDING SQUARE FOOTAGES, ARE APPROXIMATE AND ARE BASED ON CONDITIONS IN THE BUILDING AT TIME OF MEASUREMENT.

TITLE SHEET table with columns for DATE, REMARKS, and DATE.

Table with columns for PA / PM, DRAWN BY, and JOB NO.

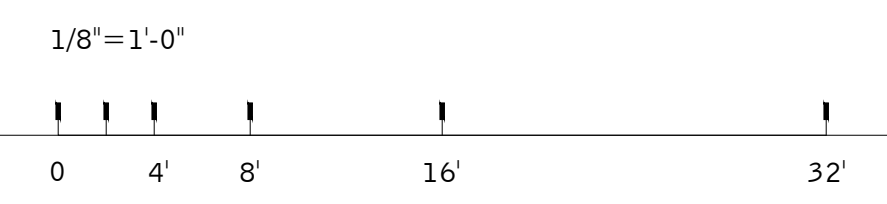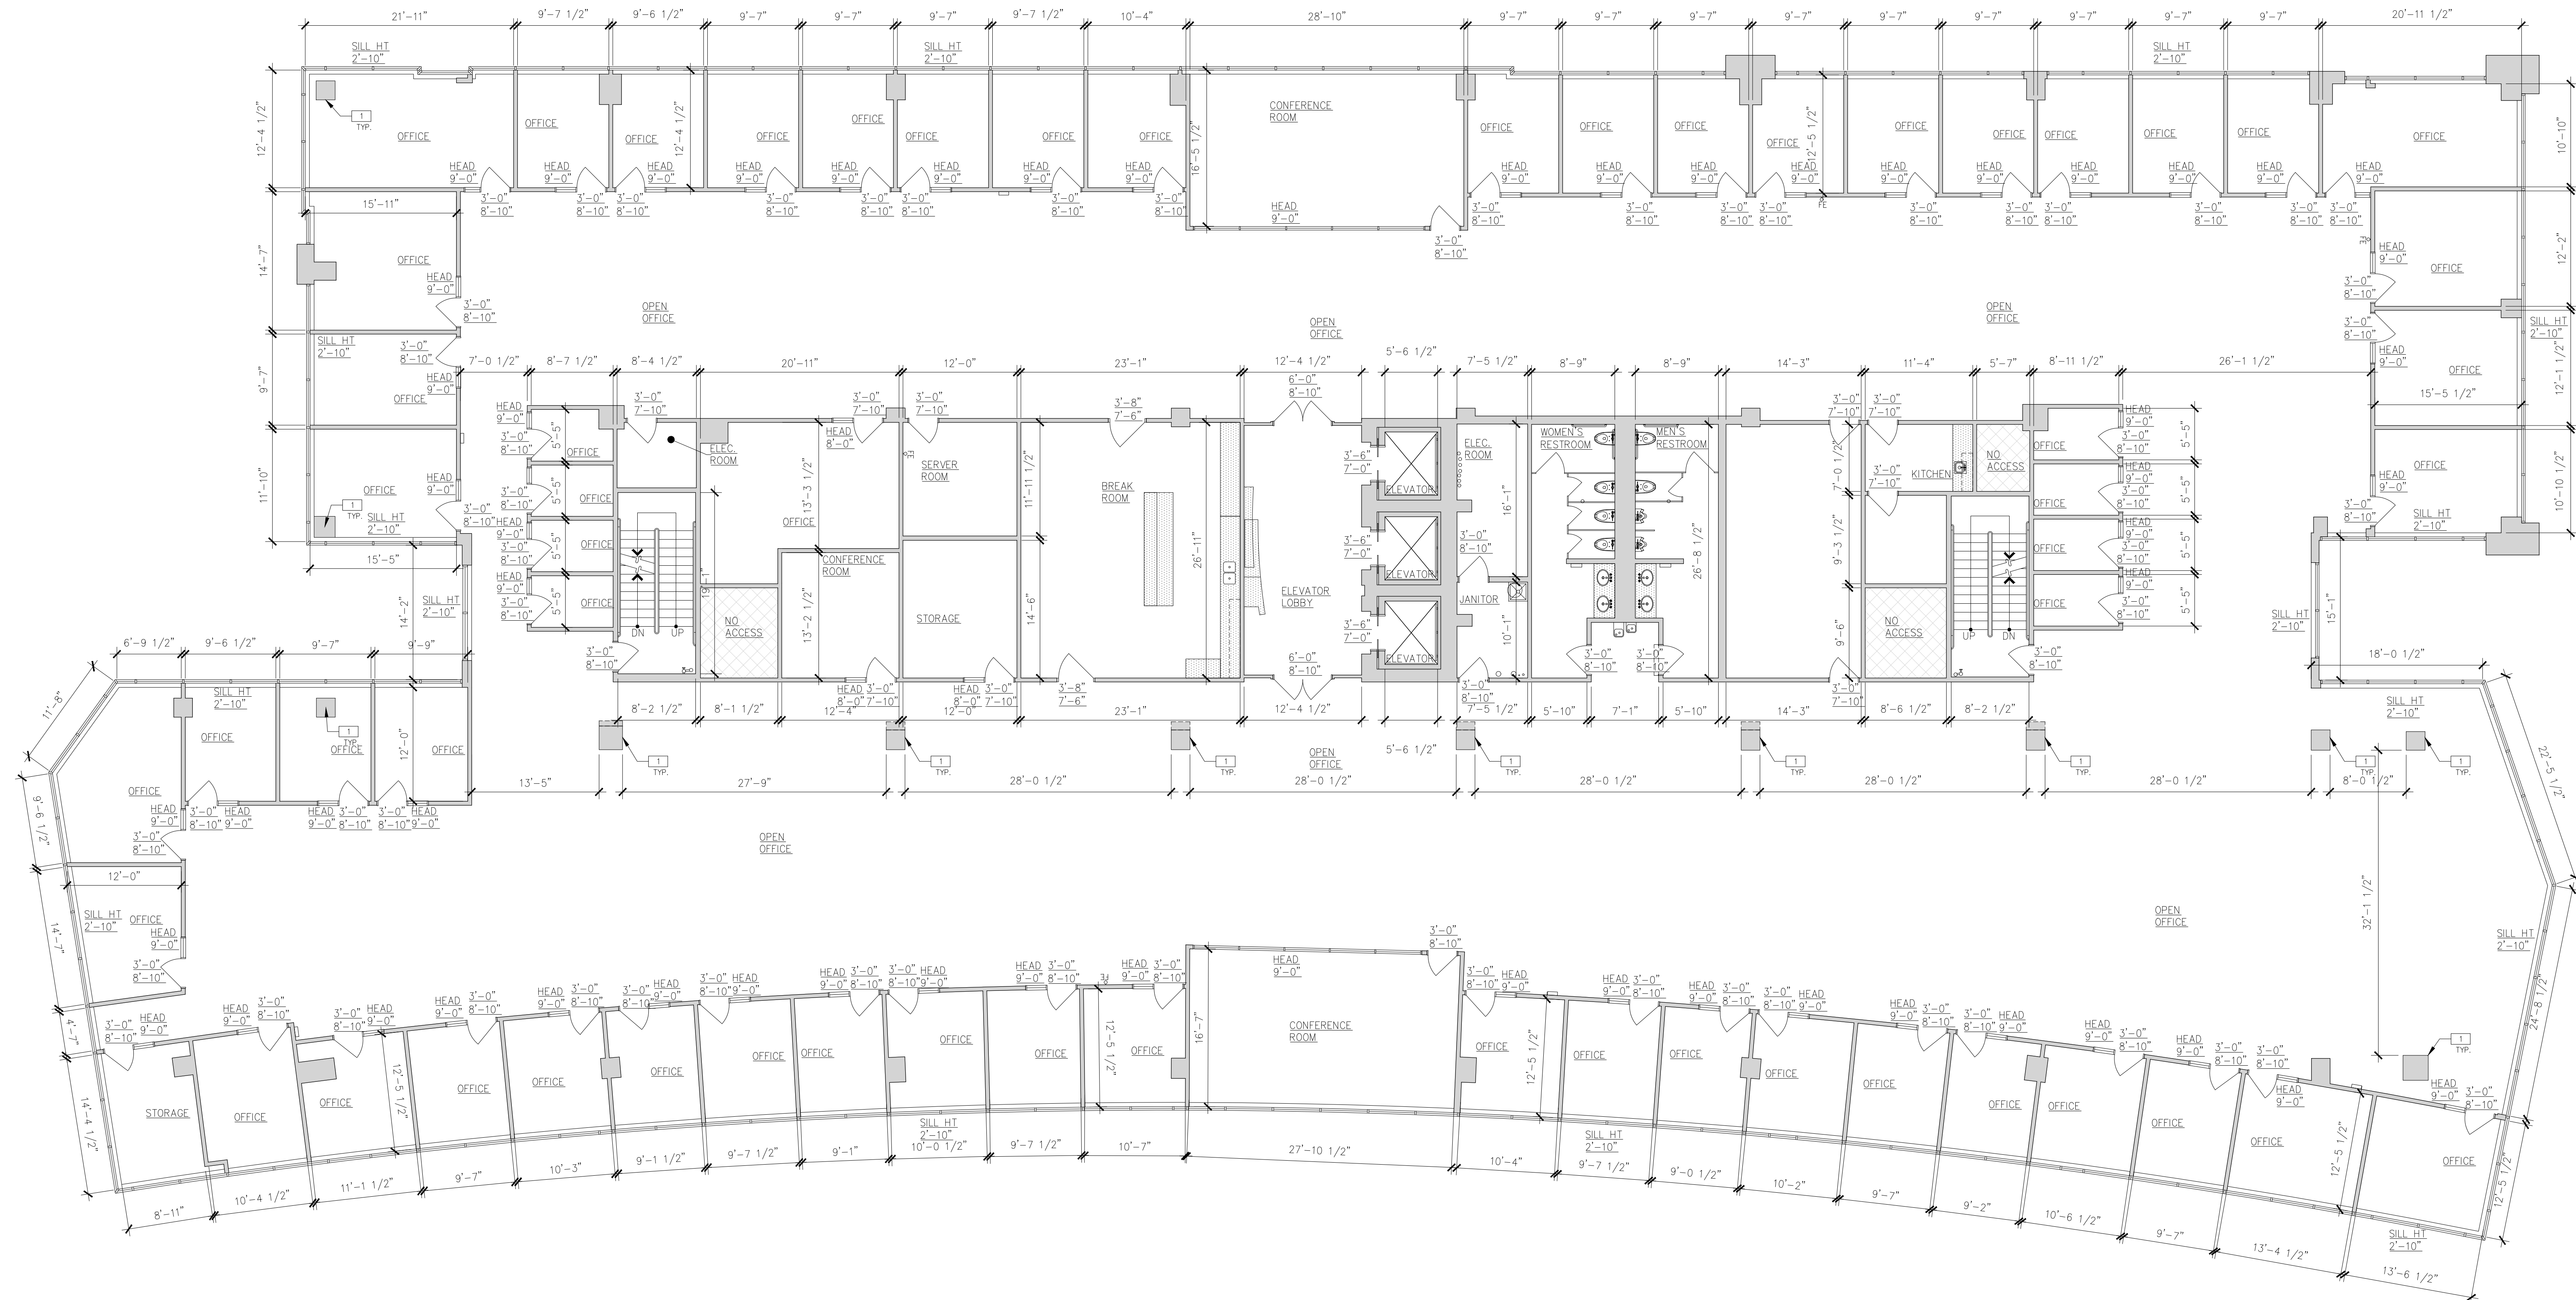

THIRD FLOOR PLAN - DIMENSIONED

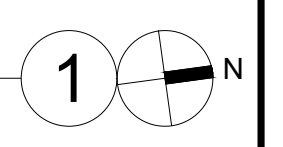

WALL LEGEND

WALL PARTITION	BASIC DESCRIPTION
	EXISTING WALL/PARTITION

LEGEND

	NOT IN SCOPE OF WORK. AREA NOT ACCESSED OR VERIFIED BY BUILDING MEASUREMENT SERVICES. WALL THICKNESSES SHOWN IN AREAS NOT VERIFIED ARE ASSUMED.
--	---

FLOOR PLAN NOTES

SEE SHEET A0.2 FOR GENERAL NOTES
 COLUMN

KEY PLAN

THIRD FLOOR PLAN - DIMENSIONED	
DATE	REMARKS

PA / PM:	
DRAWN BY:	W. BASTRUP
JOB NO.:	SD024-2003-00



SHEET
B110

architecture
 planning
 interiors
 graphics


WARE MALCOLM

10 addham
 Irvine, California 92618
 P 949.663.5121 F 949.663.1851

Irvine
 Los Angeles
 northern California
 sacramento
 san diego
 denver
 Chicago
 New Jersey

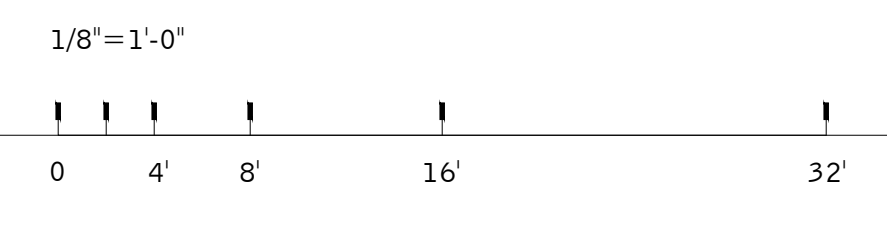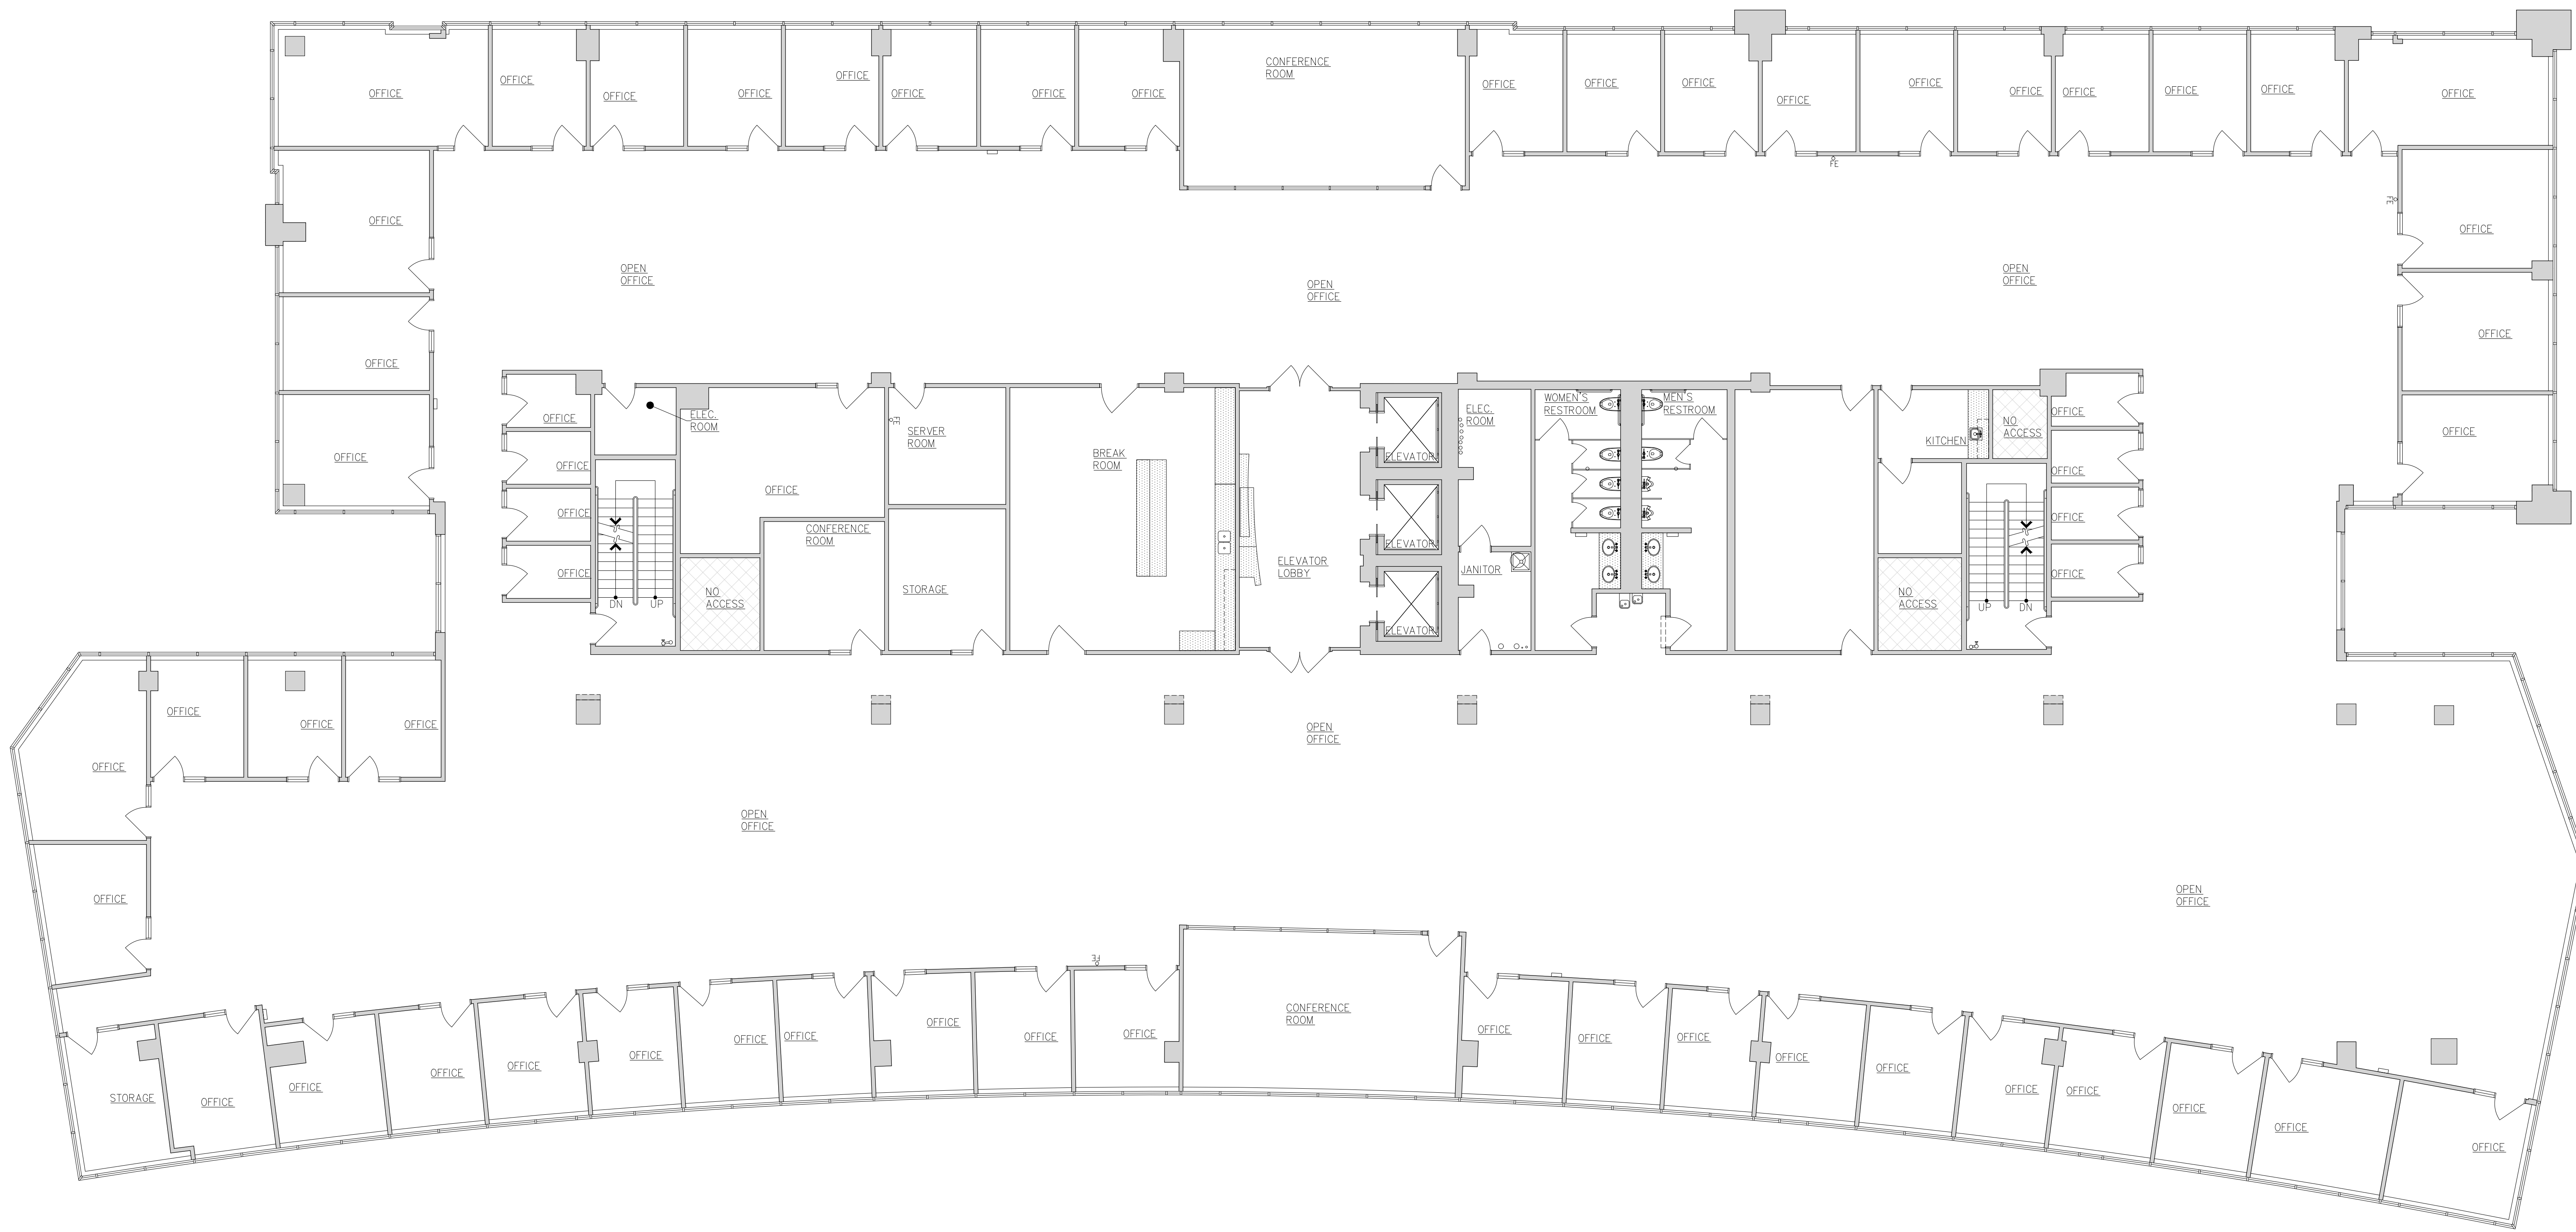

THIRD FLOOR PLAN - NON DIMENSIONED

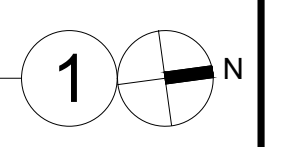


THIRD FLOOR PLAN - NON DIMENSIONED		
DATE	REVISIONS	REMARKS

PA / PM:	
DRAWN BY:	W. BASTRUP
JOB NO.:	SDG24-2003-00

SHEET
B111

ELECTRICAL PANEL SCHEDULE

1 30P3A 400AMPS 208Y/120V 3P/4W	4 30P3D 250AMPS 208Y/120V 3P/4W	7 30P3F 250AMPS 208Y/120V 3P/4W	10 30P3I 125AMPS 208Y/120V 3P/4W
2 30P3B 250AMPS 208Y/120V 3P/4W	5 3L3 250AMPS 480Y/277V 3P/4W	8 30P3G 125AMPS 208Y/120V 3P/4W	
3 30P3C 125AMPS 208Y/120V 3P/4W	6 30P3E 225AMPS 208Y/120V 3P/4W	9 30P3H 125AMPS 208Y/120V 3P/4W	

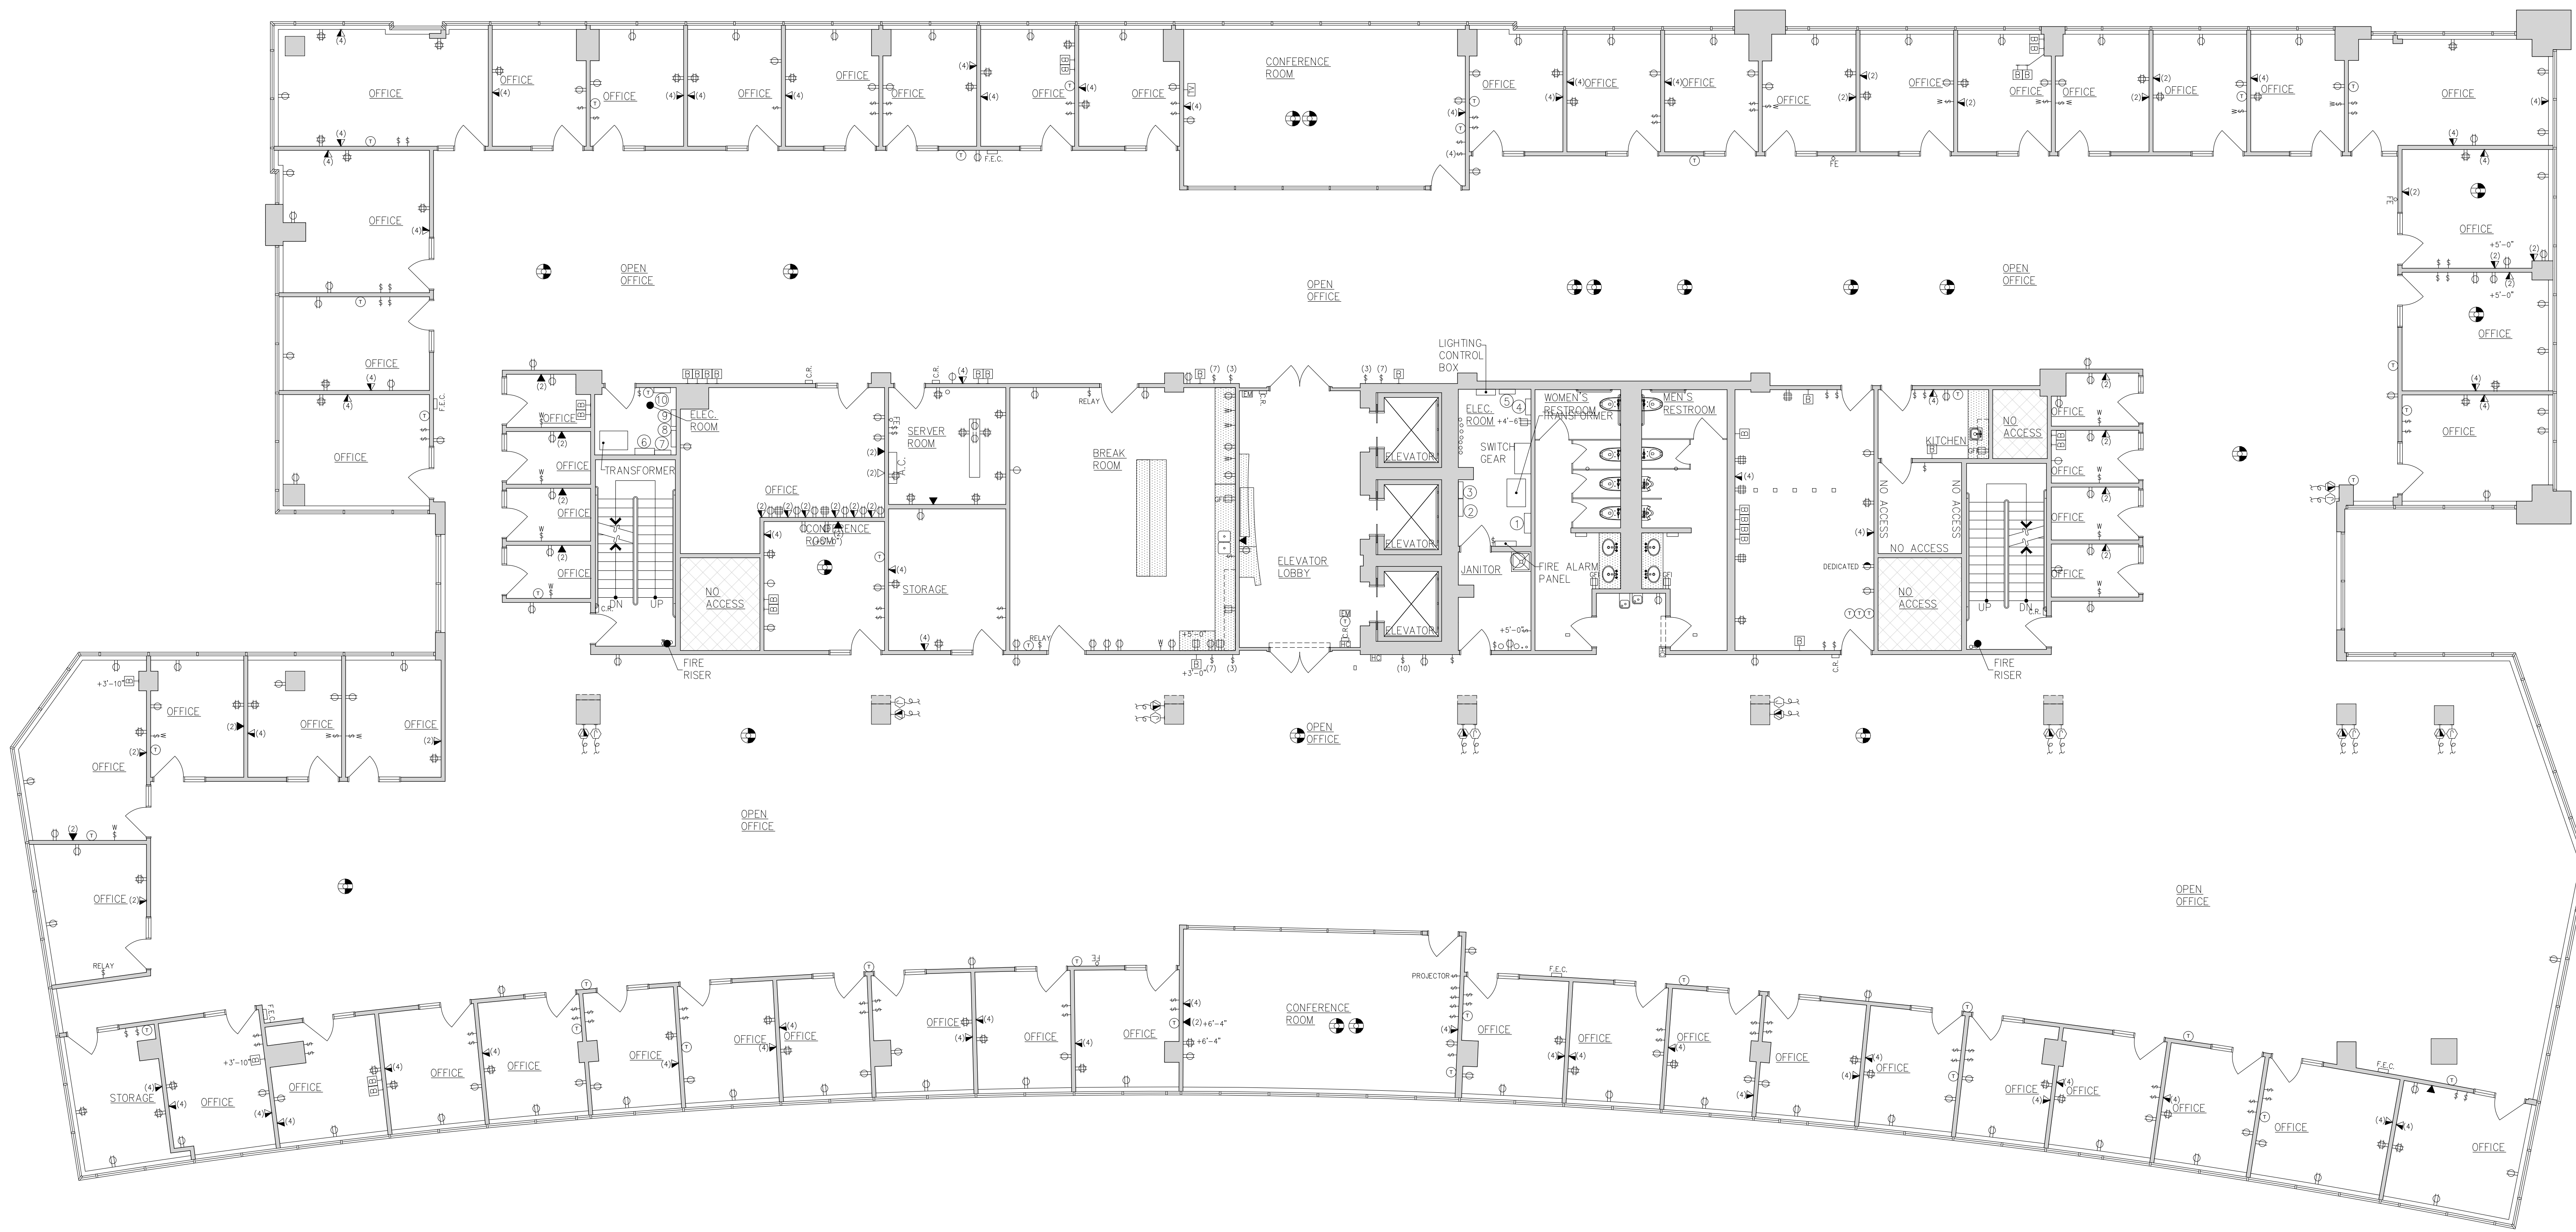

THIRD FLOOR POWER AND SIGNAL PLAN 1

POWER & SIGNAL LEGEND

- SINGLE-PLEX RECEPTACLE
- DUPLEX RECEPTACLE
- DUPLEX RECEPTACLE, MOUNTED ABOVE COUNTER W/SWITCH
- DUPLEX RECEPTACLE, MOUNTED ABOVE COUNTER OR SPLASH
- FOURPLEX RECEPTACLE
- FOURPLEX RECEPTACLE, MOUNTED ABOVE COUNTER OR SPLASH

POWER & SIGNAL LEGEND

- TELEPHONE OUTLET MUD RING, WALL-MOUNTED
- DEDICATED DUPLEX RECEPTACLE
- DATA OUTLET MUD RING, WALL-MOUNTED
- C DAX CABLE
- COMBINATION TELEPHONE/DATA FEED, CEILING-MOUNTED
- TIMER
- C.R., WALL-MOUNTED JUNCTION BOX FOR CARD READER

POWER & SIGNAL LEGEND

- DEDICATED OUTLET 20AMP/250V
- FIRE EXTINGUISHER CABINET
- FIRE STROBE
- MOTION SWITCH
- WATER LINE
- FIRE EXTINGUISHER
- THERMOSTAT

POWER & SIGNAL LEGEND

- BLANK PLATE
- CEILING-MOUNTED FIRE EXIT SIGN
- C.R., WALL-MOUNTED JUNCTION BOX FOR CARD READER
- COMBINATION DUPLEX RECEPTACLE/DATA OUTLET, MOUNTED FLUSH IN FLOOR
- EMERGENCY EXIT BUTTON
- HANDICAP BUTTON
- RELAY SWITCH
- PROJECTOR SCREEN SWITCH

POWER & SIGNAL LEGEND

- AUDIO VISUAL PANEL
- WIRE CHASE
- ALARM PANEL
- NETWORK
- HDMI PANEL
- VERTICAL POWER STRIP

E:\BMS\Projects\SDC24-2003-00\OUT\2024-02-21\2003_SHEETS.dwg

THESE DRAWINGS AND SPECIFICATIONS ARE THE PROPERTY AND COPYRIGHT OF WARE MALCOLM AND SHALL NOT BE USED ON ANY OTHER WORK EXCEPT BY AGREEMENT WITH WARE MALCOLM. WRITTEN DIMENSIONS SHALL TAKE PREFERENCE OVER SCALED DIMENSIONS AND SHALL BE VERIFIED ON THE JOB SITE. ANY DISCREPANCY SHALL BE BROUGHT TO THE NOTICE OF WARE MALCOLM PRIOR TO THE COMMENCEMENT OF ANY WORK.

THIRD FLOOR POWER AND SIGNAL PLAN

DATE	REVISIONS	REMARKS

PA / PM:	
DRAWN BY:	W. BASTRUP
JOB NO.:	SDC24-2003-00



SHEET
B112

architecture
planning
interiors
graphics


WARE MALCOLM

10 ebbott
irvine, california 92618
P:949.663.5128 F:949.663.1891

irvine
los angeles
northem california
sacramento
san diego
denver
chicago
new jersey

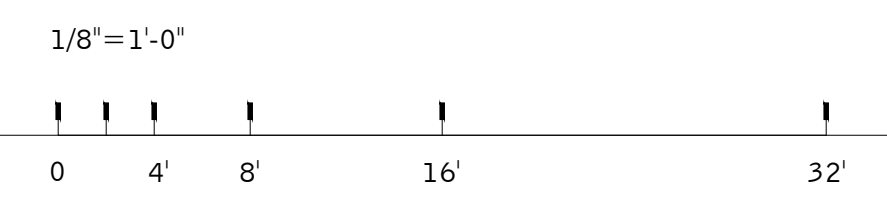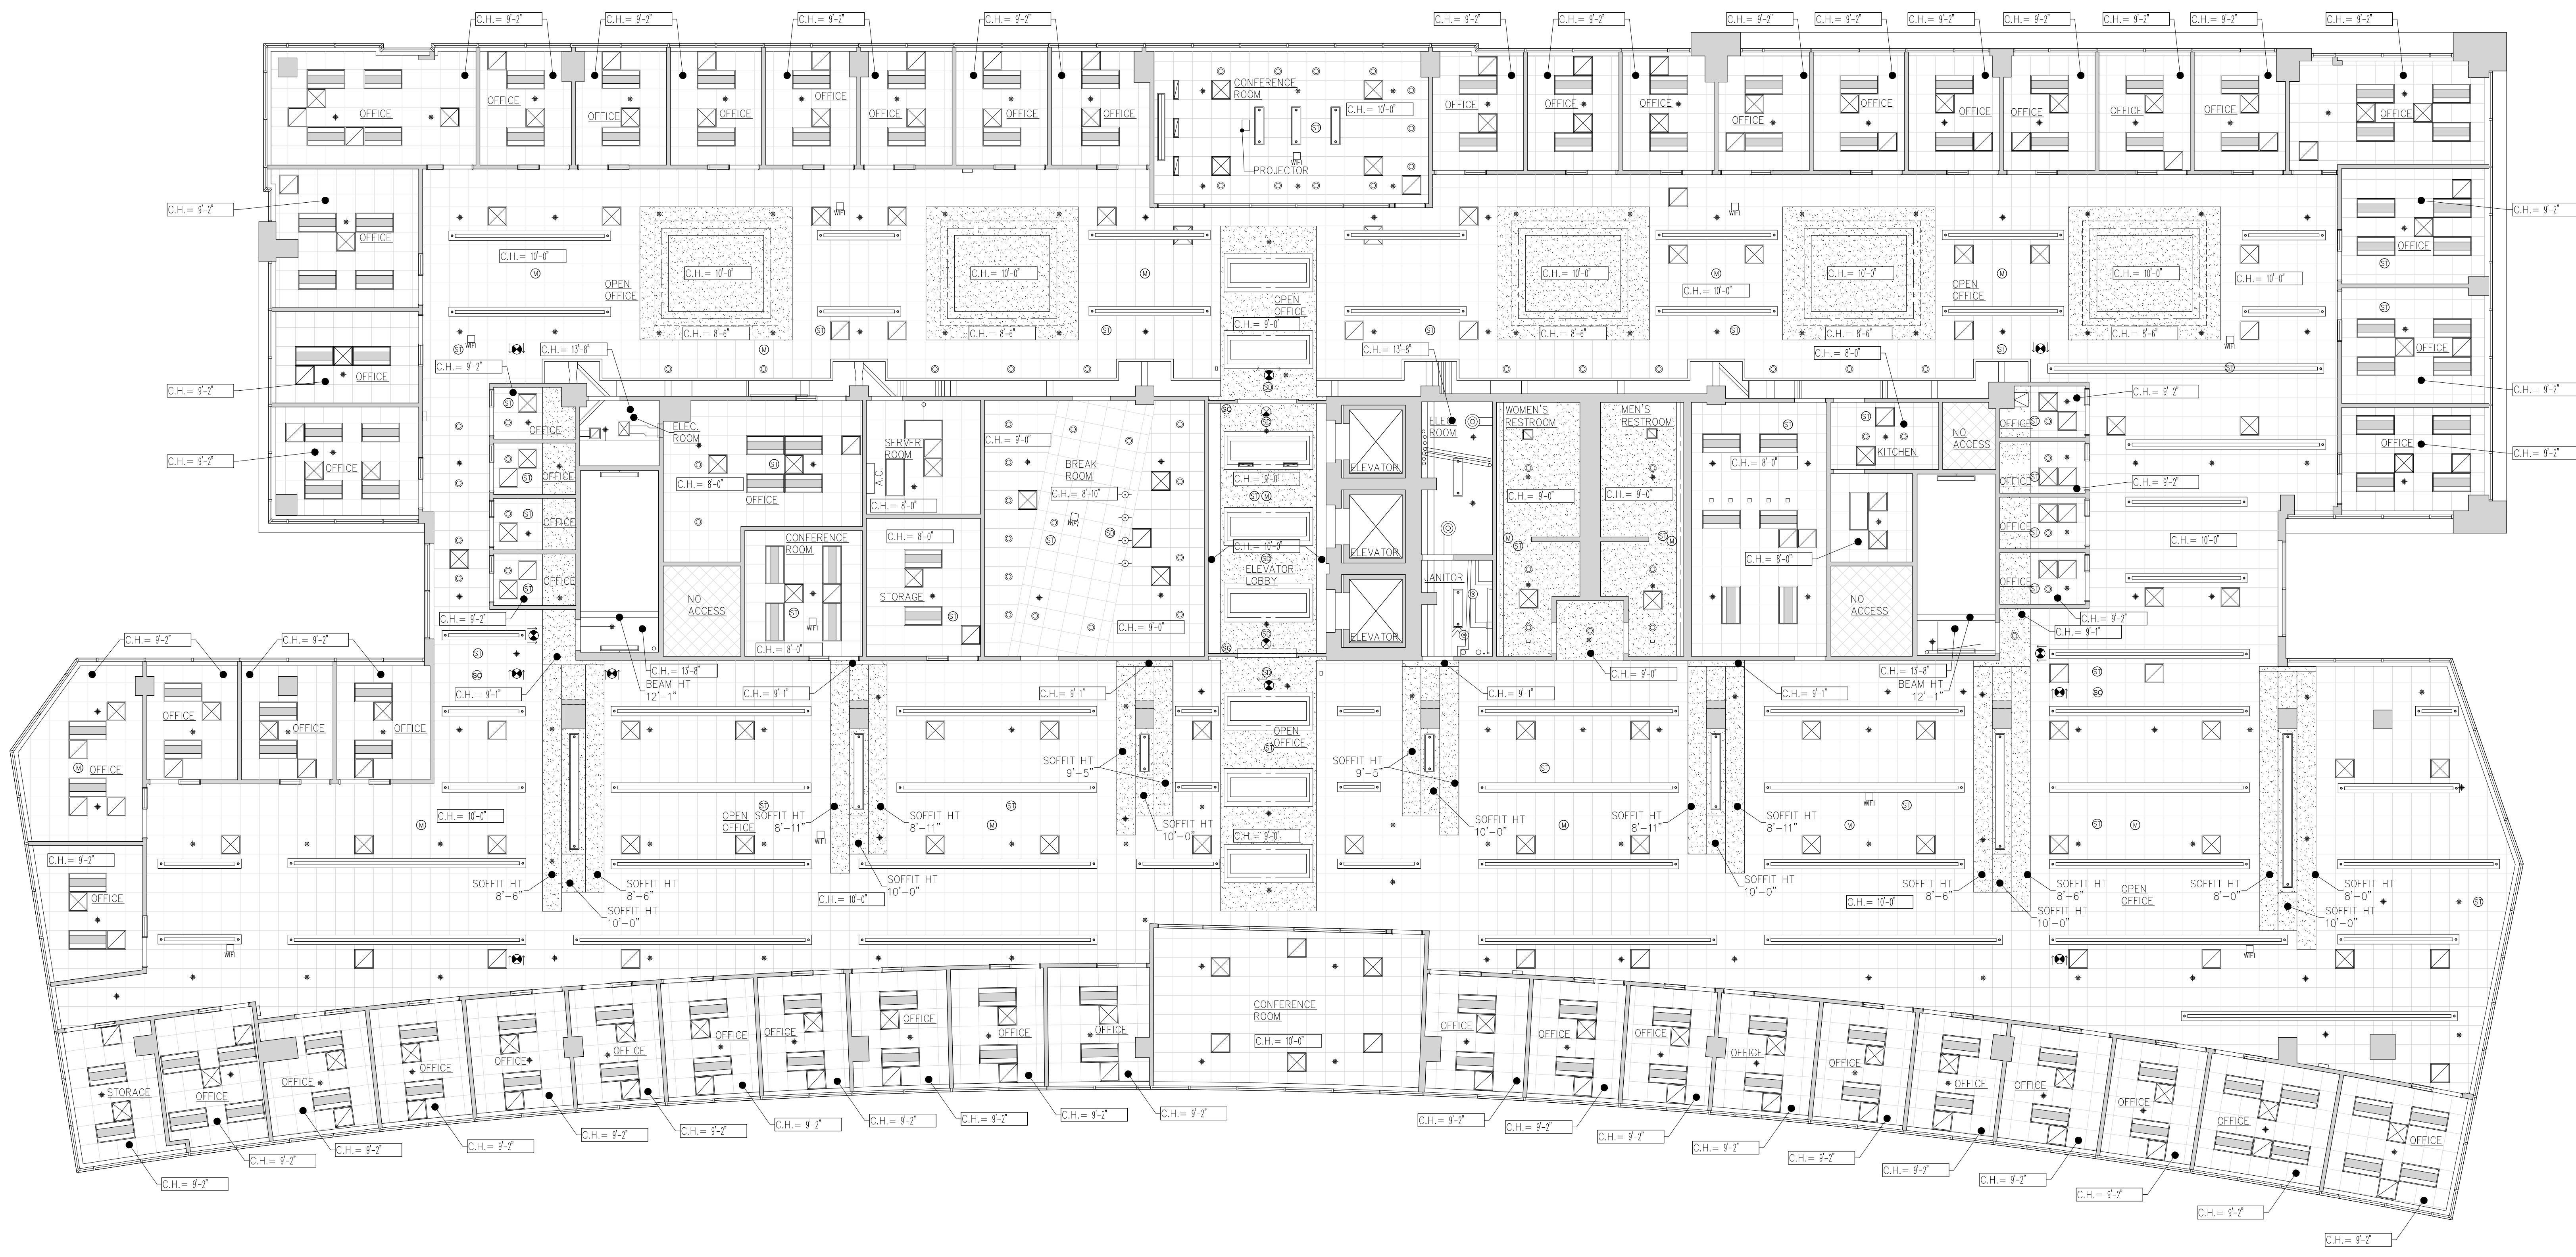

THIRD FLOOR REFLECTED CEILING PLAN

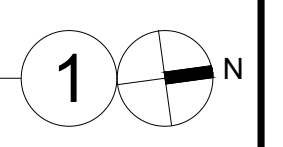

LEGEND

	EXISTING 2'x2' SUSPENDED CEILING GRID & TILES
	EXISTING 2'x4' SUSPENDED CEILING GRID & TILES
	EXISTING GYPSUM BOARD CEILING
	EXISTING SUPPLY AIR GRILL
	EXISTING RETURN AIR GRILL
	2'x4' INDIRECT LIGHT FIXTURE.

LEGEND

	2'x2' INDIRECT LIGHT FIXTURE.
	1'x4' PENDANT-HUNG LIGHT FIXTURE.
	2'x4' LIGHT FIXTURE WITH PRISMATIC LENS
	CEILING-MOUNTED EXIT SIGN
	CEILING SPRINKLER
	RECESSED CIRCULAR DOWNLIGHT.
	PENDANT-HUNG LIGHT FIXTURE.

LEGEND



	SMOKE DETECTOR
	COVE LIGHT
	EXISTING CEILING ACCESS
	WALL-MOUNTED 4' WRAP-AROUND LIGHT FIXTURE.
	CEILING MOUNTED FIRE ALARM STROBE
	MOTION SENSOR DETECTOR
	WI-FI ROUTER

THIRD FLOOR REFLECTED CEILING PLAN


DATE	REVISIONS	REMARKS

PA / PM:	
DRAWN BY:	W. BASTRUP
JOB NO.:	SD024-2003-00

SHEET
B113

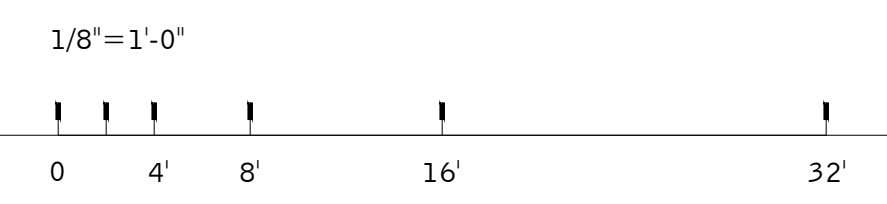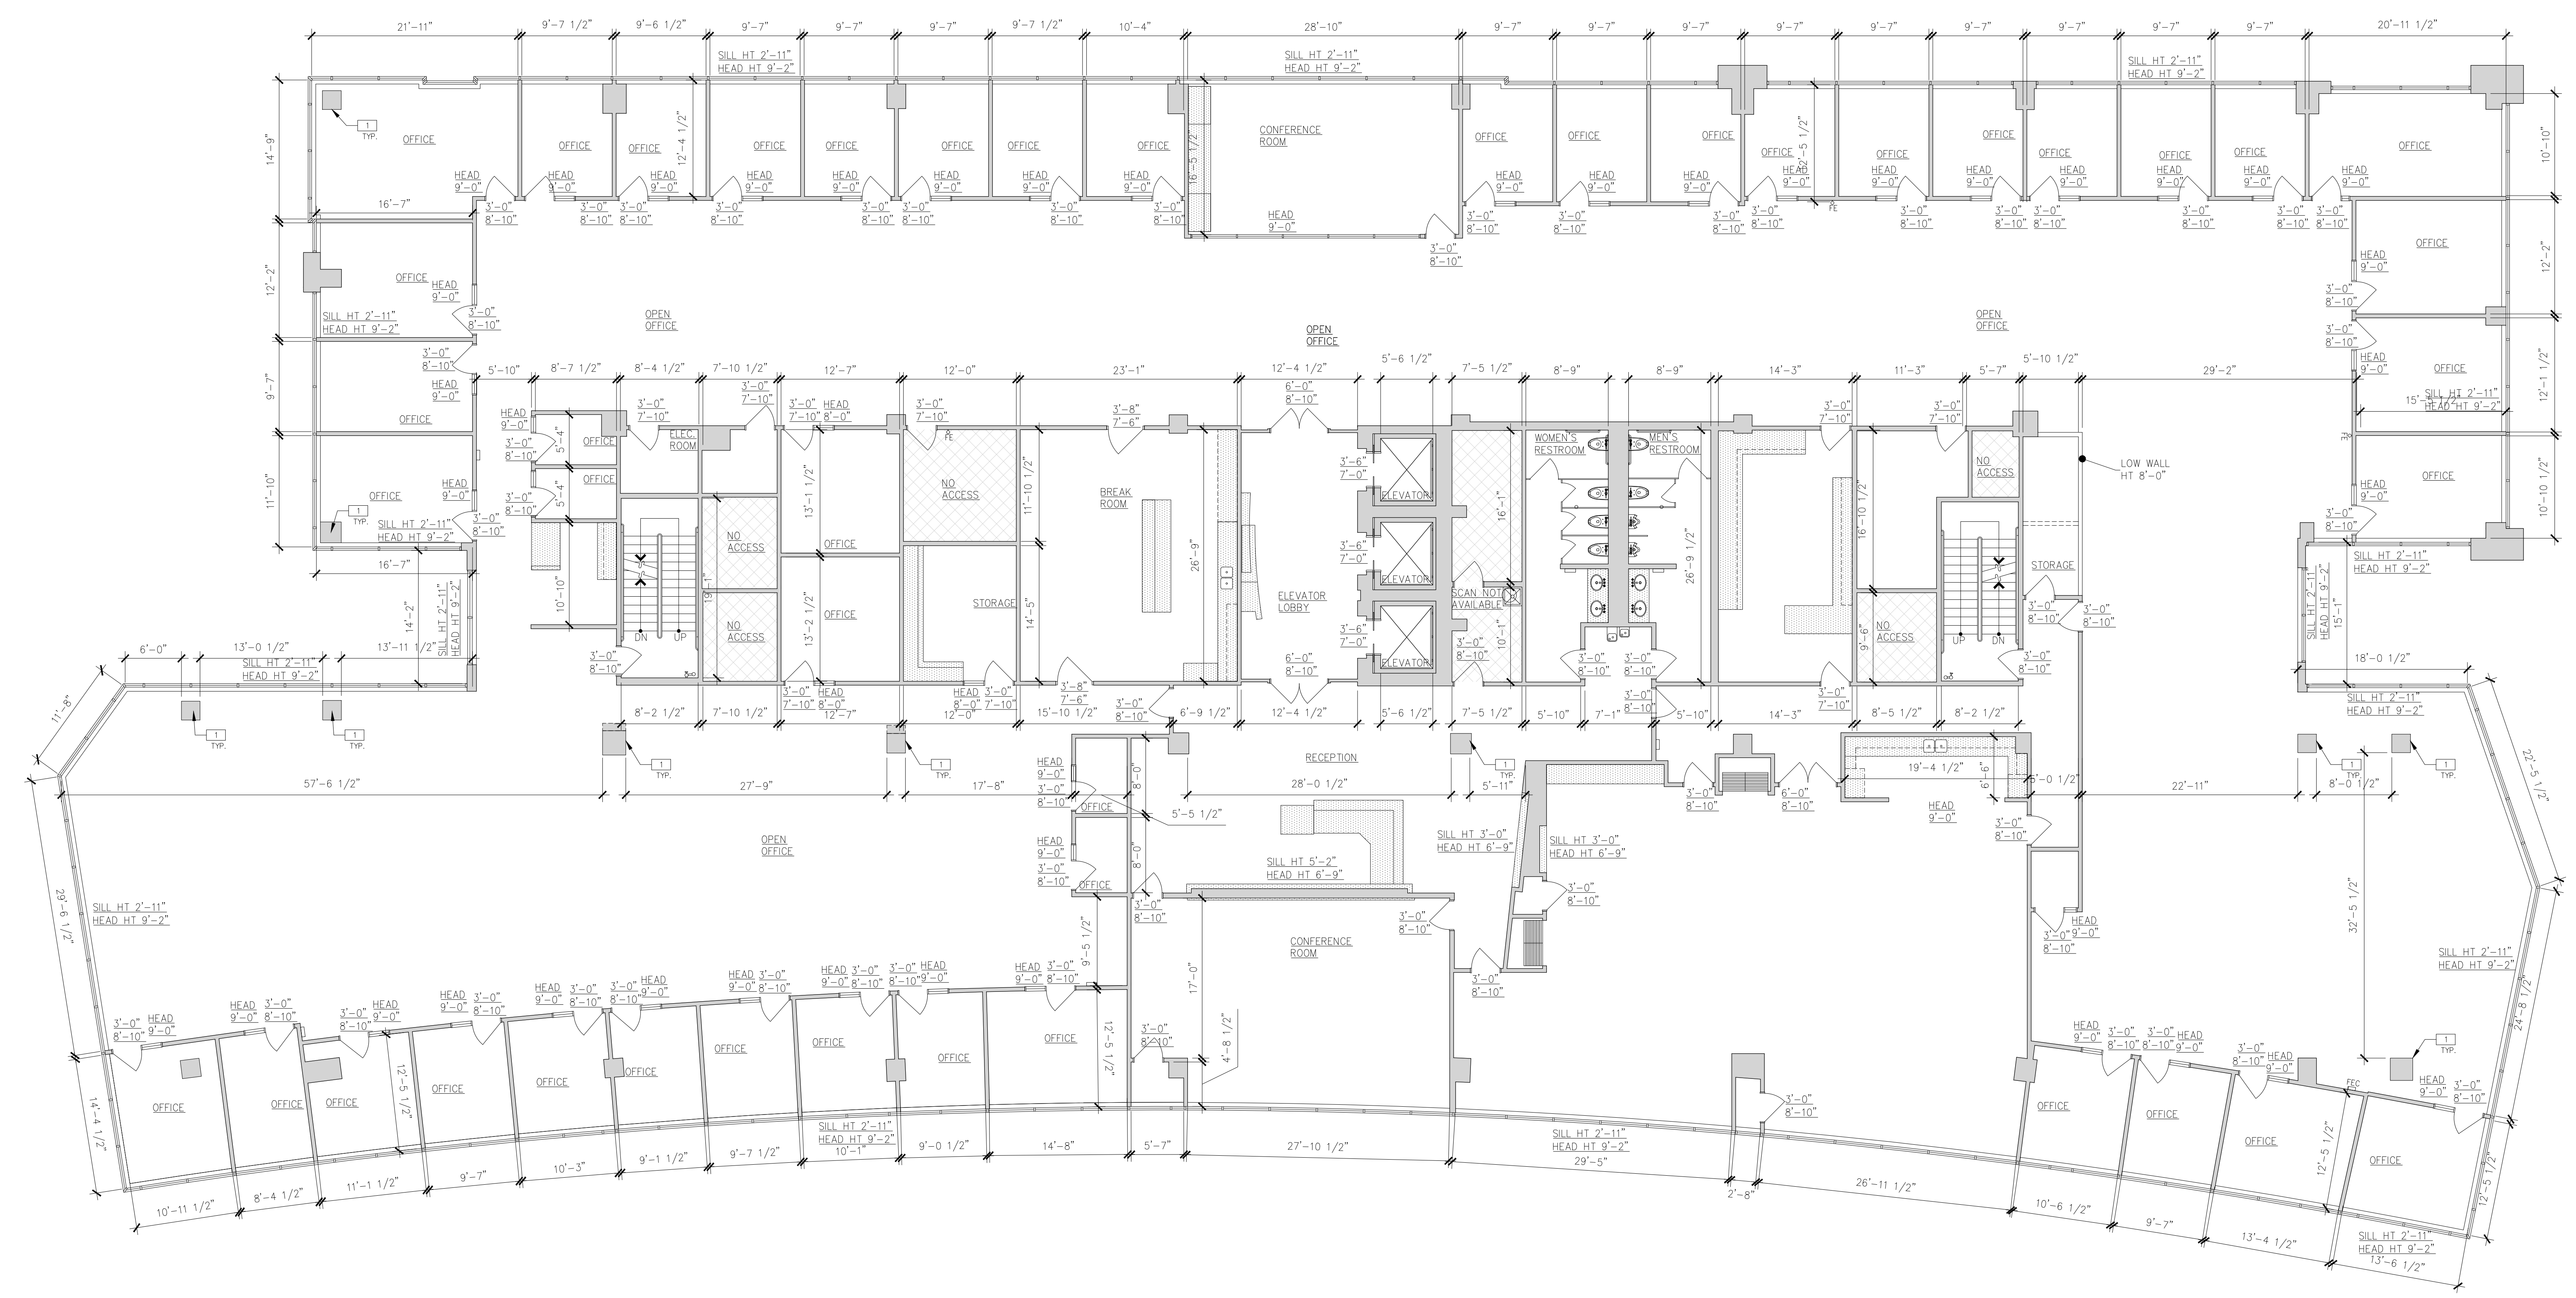

FOURTH FLOOR PLAN - DIMENSIONED

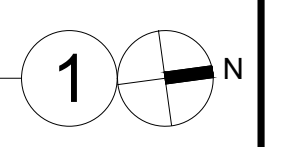

WALL LEGEND

WALL PARTITION	BASIC DESCRIPTION
	EXISTING WALL/PARTITION

LEGEND

	NOT IN SCOPE OF WORK. AREA NOT ACCESSED OR VERIFIED BY BUILDING MEASUREMENT SERVICES. WALL THICKNESSES SHOWN IN AREAS NOT VERIFIED ARE ASSUMED.
--	---

FLOOR PLAN NOTES

SEE SHEET A0.2 FOR GENERAL NOTES

COLUMN

KEY PLAN


FOURTH FLOOR PLAN - DIMENSIONED

DATE	REVISIONS	REMARKS


PA / PM:	
DRAWN BY:	W. BASTRUP
JOB NO.:	SDG24-2003-00

SHEET

B120

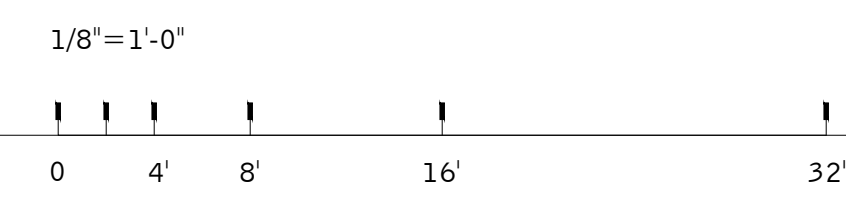

FOURTH FLOOR PLAN - NON DIMENSIONED

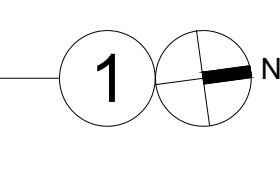

architecture
planning
interiors
graphics

WARE MALCOLM

10 eadman
irvine california 92618
P: 949.666.9726 F: 949.666.1181

irvine
los angeles
northern california
sacramento
san diego
denver
chicago
new jersey

FOURTH FLOOR PLAN - NON DIMENSIONED

DATE	REVISIONS	DATE	REVISIONS



PA / PM:	
DRAWN BY:	W. BASTRUP
JOB NO.:	SDG24-2003-00

SHEET
B121

THESE DRAWINGS AND SPECIFICATIONS ARE THE PROPERTY AND COPYRIGHT OF WARE MALCOLM AND SHALL NOT BE USED ON ANY OTHER WORK EXCEPT BY AGREEMENT WITH WARE MALCOLM. WRITTEN DIMENSIONS SHALL TAKE PREFERENCE OVER SCALED DIMENSIONS AND SHALL BE VERIFIED ON THE JOB SITE. ANY DISCREPANCY SHALL BE BROUGHT TO THE NOTICE OF WARE MALCOLM PRIOR TO THE COMMENCEMENT OF ANY WORK.

ELECTRICAL PANEL SCHEDULE

1 30P4A 400AMPS 208Y/120V 3P/4W	4 MICRO NOTHING CONTROL PANEL	7 4LA 125AMPS 208Y/120V 3P/4W	10 30P4G 250AMPS 208Y/120V 3P/4W
2 30P4B 250AMPS 208Y/120V 3P/4W	5 3L4 250AMPS 208Y/120V 3P/4W	8 30P4E 400AMPS 408Y/277V 3P/4W	
3 30P4C 125AMPS 208Y/120V 3P/4W	6 4HA 125AMPS 408Y/277V 3P/4W	9 30P4F 125AMPS 208Y/120V 3P/4W	

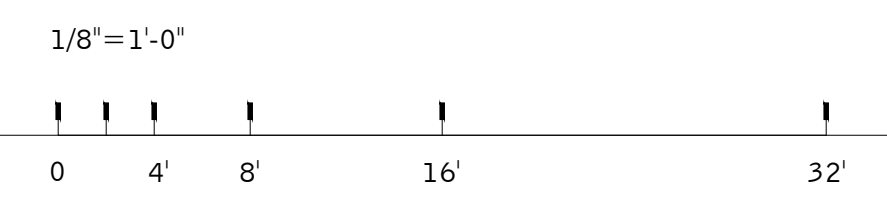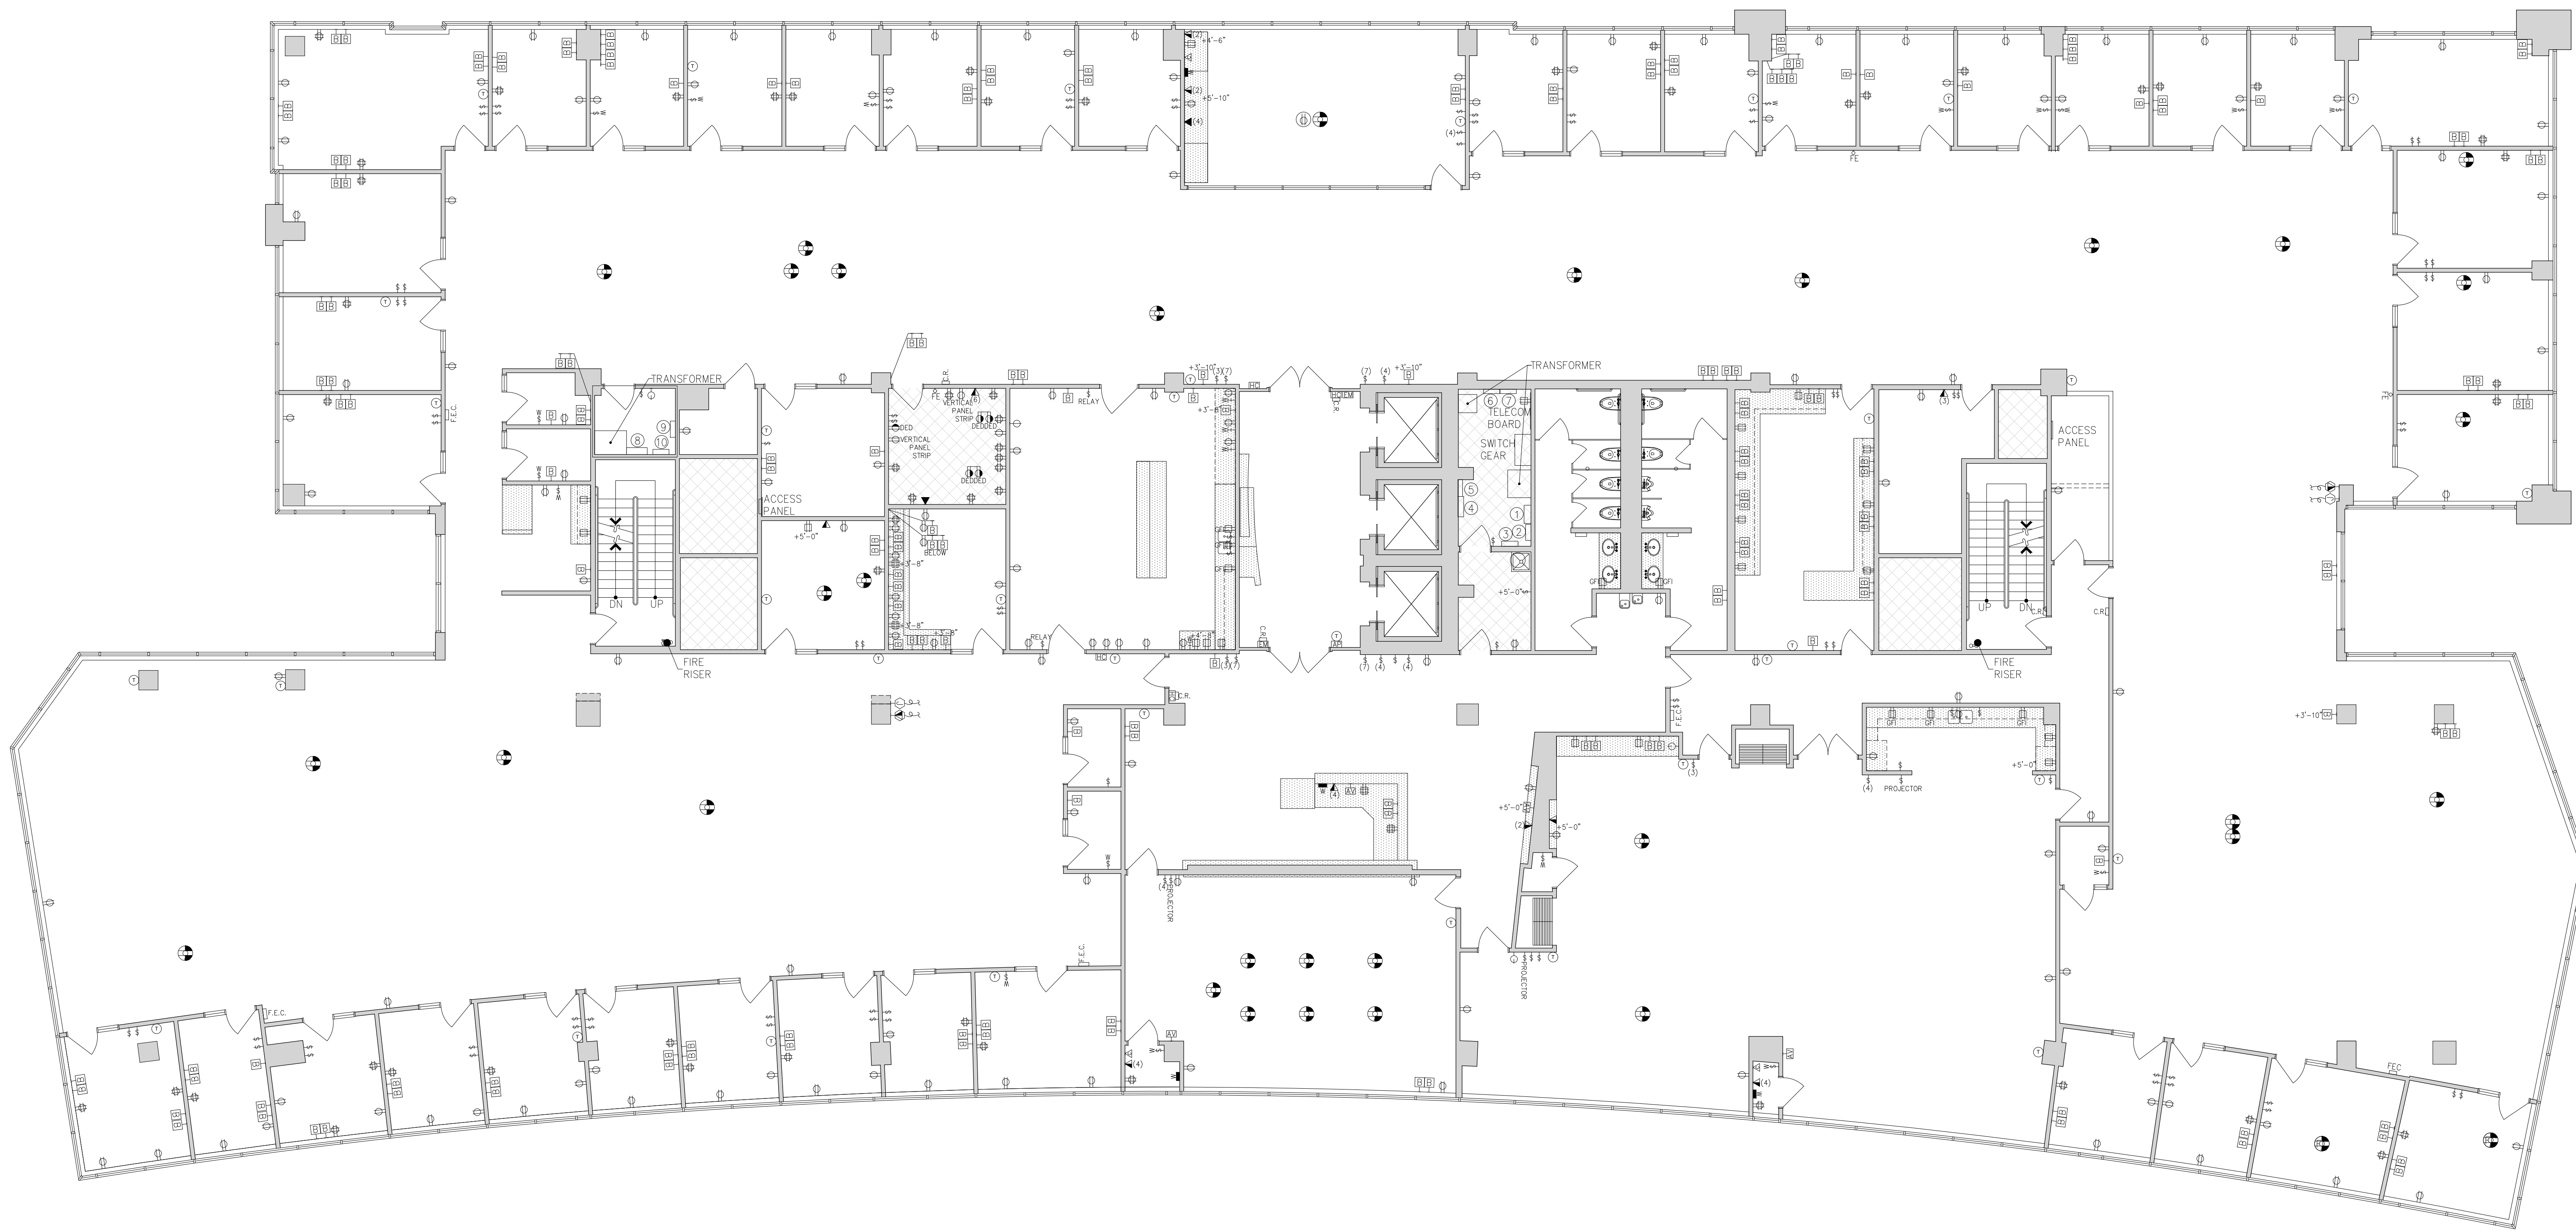

FOURTH FLOOR POWER AND SIGNAL PLAN 1

POWER & SIGNAL LEGEND

- SINGLE-PLEX RECEPTACLE
- DUPLEX RECEPTACLE
- DUPLEX RECEPTACLE, MOUNTED ABOVE COUNTER W/SWITCH
- DUPLEX RECEPTACLE, MOUNTED ABOVE COUNTER OR SPLASH
- FOURPLEX RECEPTACLE
- FOURPLEX RECEPTACLE, MOUNTED ABOVE COUNTER OR SPLASH

POWER & SIGNAL LEGEND

- TELEPHONE OUTLET MUD RING, WALL-MOUNTED
- DEDICATED DUPLEX RECEPTACLE
- DATA OUTLET MUD RING, WALL-MOUNTED
- C DAX CABLE
- COMBINATION TELEPHONE/DATA FEED, CEILING-MOUNTED
- TIMER
- C.R., WALL-MOUNTED JUNCTION BOX FOR CARD READER

POWER & SIGNAL LEGEND

- DED, DEDICATED OUTLET 20AMP/250V
- FEC, FIRE EXTINGUISHER CABINET
- FS, FIRE STROBE
- MOTION SWITCH
- WATER LINE
- FIRE EXTINGUISHER
- T, THERMOSTAT

POWER & SIGNAL LEGEND

- BLANK PLATE
- CEILING-MOUNTED FIRE EXIT SIGN
- C.R., WALL-MOUNTED JUNCTION BOX FOR CARD READER
- COMBINATION DUPLEX RECEPTACLE/DATA OUTLET, MOUNTED FLUSH IN FLOOR
- EM, EMERGENCY EXIT BUTTON
- HC, HANDICAP BUTTON
- RELAY SWITCH
- PROJECTOR SCREEN SWITCH

POWER & SIGNAL LEGEND

- AV, AUDIO VISUAL PANEL
- W, WIRE CHASE
- AP, ALARM PANEL
- N, NETWORK
- HDMI, HDMI PANEL
- P, VERTICAL POWER STRIP

E:\BMS\Projects\SDG24-2003-00\OUT\2024-02-21\2003_SHEETS.dwg

THESE DRAWINGS AND SPECIFICATIONS ARE THE PROPERTY AND COPYRIGHT OF WARE MALCOLM AND SHALL NOT BE USED ON ANY OTHER WORK EXCEPT BY AGREEMENT WITH WARE MALCOLM. WRITTEN DIMENSIONS SHALL TAKE PREFERENCE OVER SCALED DIMENSIONS AND SHALL BE VERIFIED ON THE JOB SITE. ANY DISCREPANCY SHALL BE BROUGHT TO THE NOTICE OF WARE MALCOLM PRIOR TO THE COMMENCEMENT OF ANY WORK.

FOURTH FLOOR POWER AND SIGNAL PLAN	
DATE	REMARKS



PA / PM:	
DRAWN BY:	W. BASTRUP
JOB NO.:	SDG24-2003-00

SHEET
B122


architecture
planning
interiors
graphics

WARE MALCOLM
10 eddman
irvine, california 92618
P:949.663.5121 F:949.663.1891

irvine
los angeles
northridge, california
sacramento
san diego
denver
chicago
new jersey

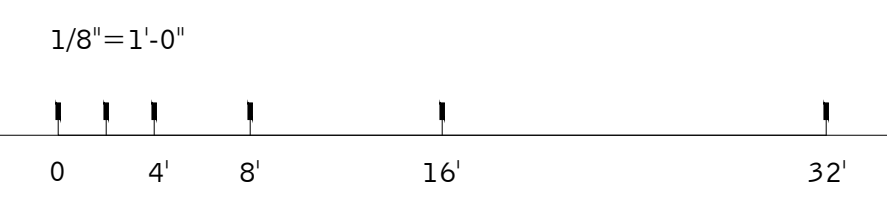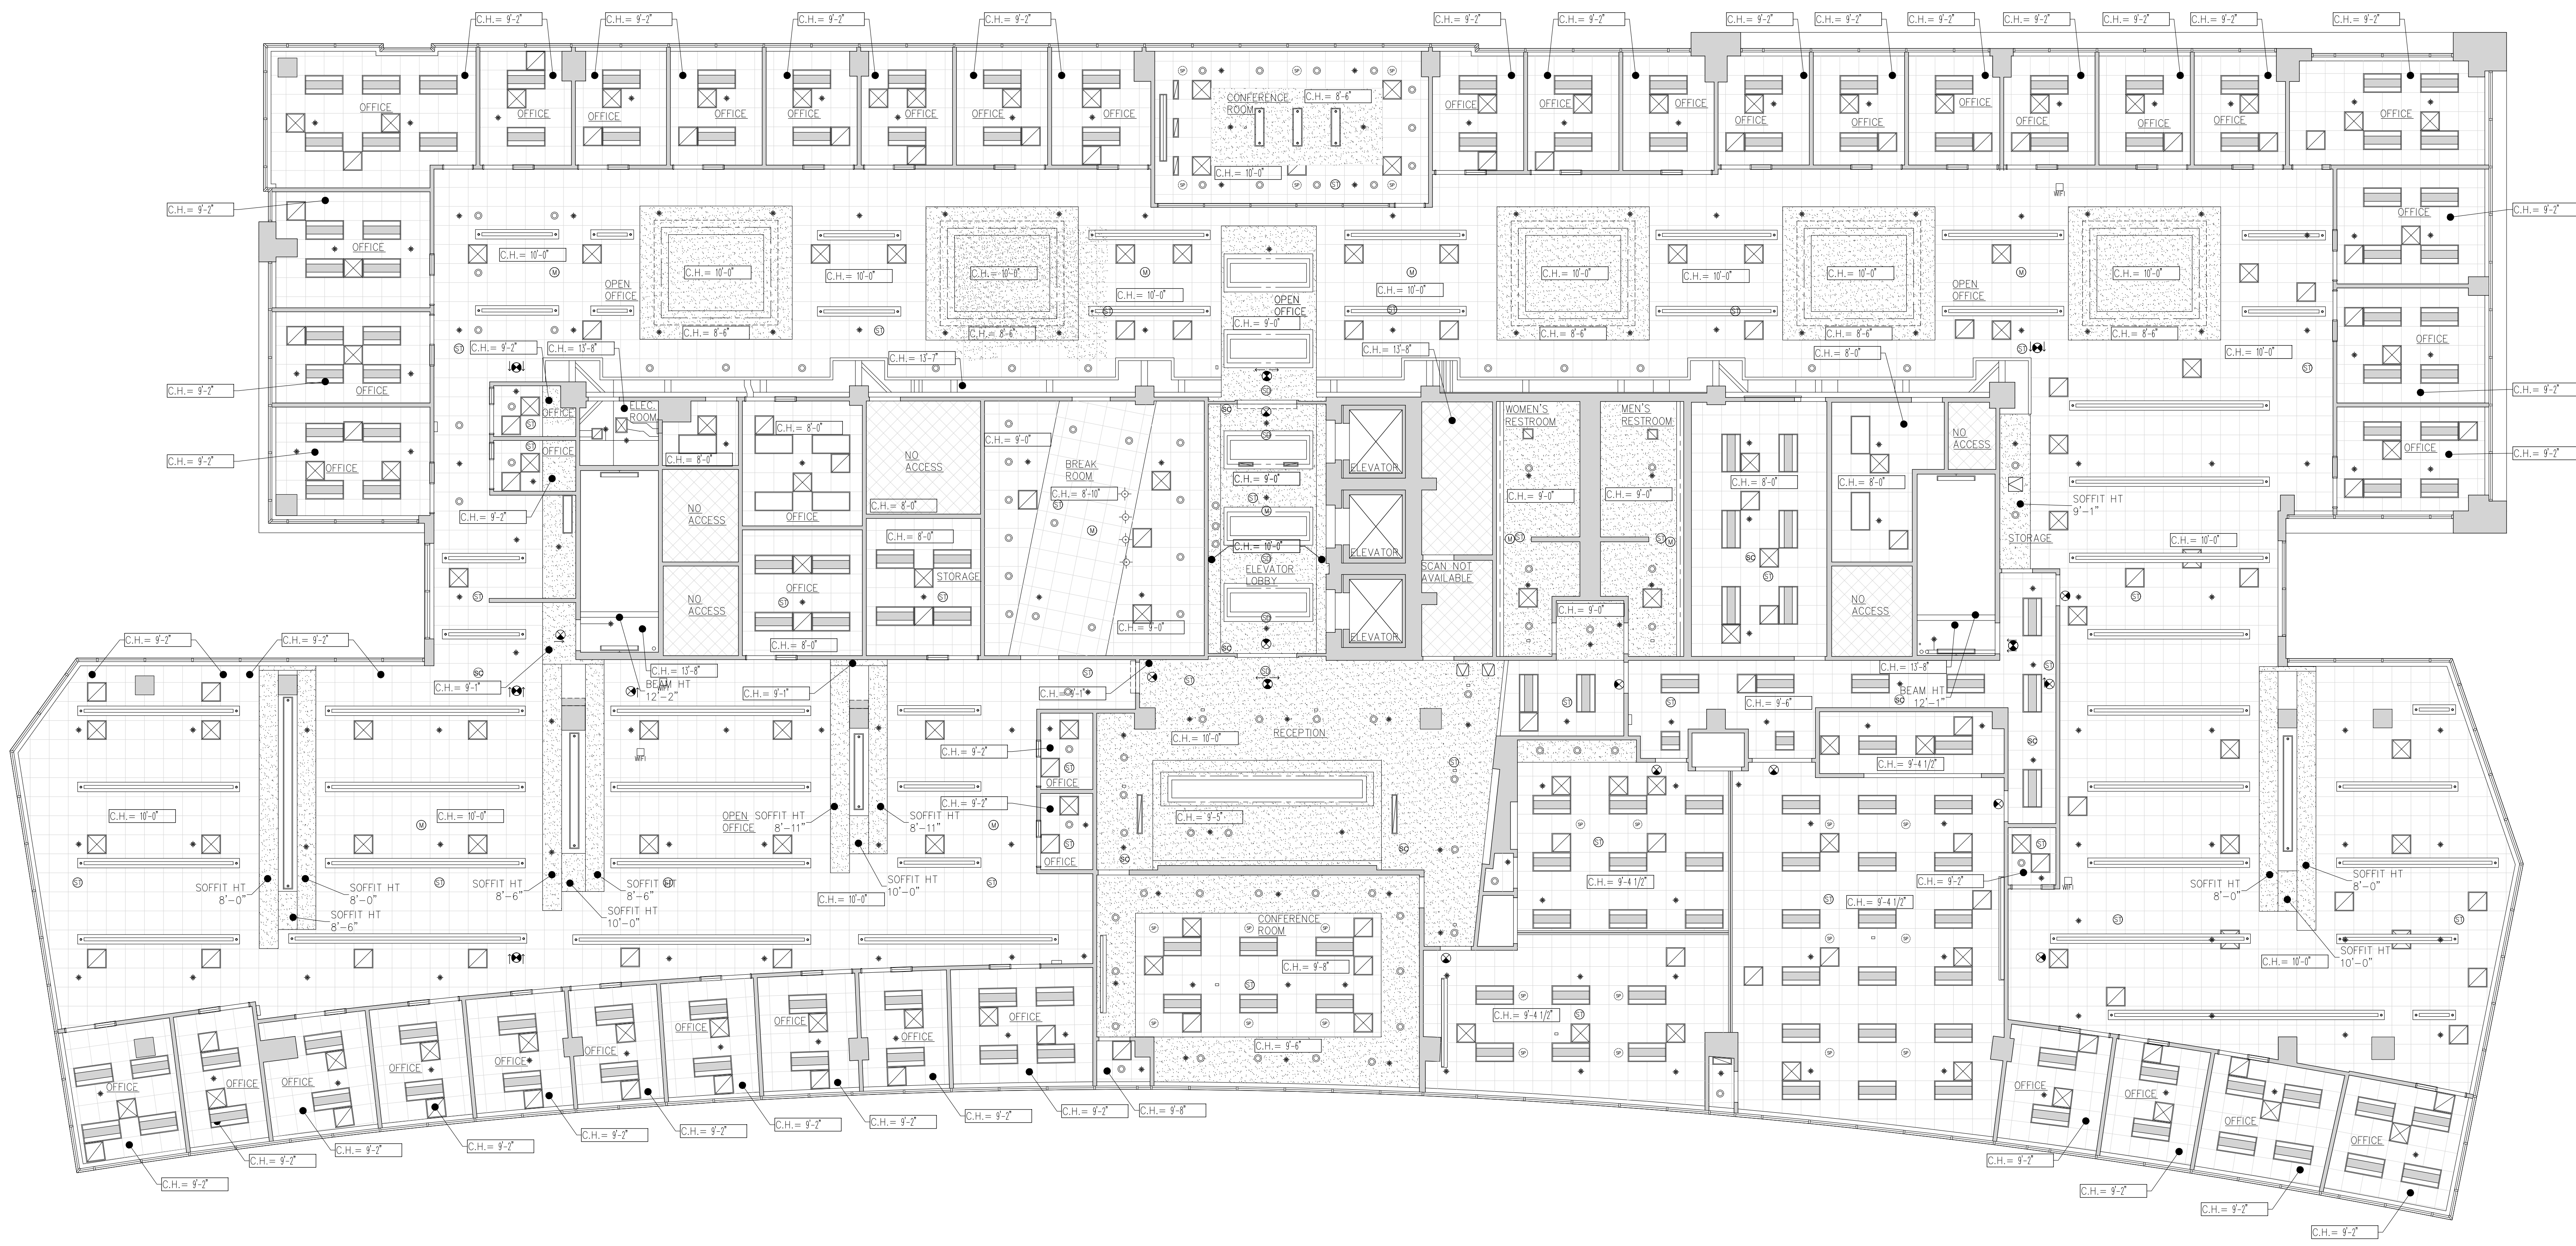

FOURTH FLOOR REFLECTED CEILING PLAN

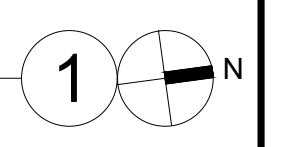

LEGEND

	EXISTING 2'x2' SUSPENDED CEILING GRID & TILES
	EXISTING 2'x4' SUSPENDED CEILING GRID & TILES
	EXISTING GYPSUM BOARD CEILING
	EXISTING SUPPLY AIR GRILL
	EXISTING RETURN AIR GRILL
	2'x4' INDIRECT LIGHT FIXTURE.

LEGEND

	2'x2' INDIRECT LIGHT FIXTURE.
	1'x4' PENDANT-HUNG LIGHT FIXTURE.
	2'x4' LIGHT FIXTURE WITH PRISMATIC LENS
	CEILING-MOUNTED EXIT SIGN
	CEILING SPRINKLER
	RECESSED CIRCULAR DOWNLIGHT.
	PENDANT-HUNG LIGHT FIXTURE.

LEGEND



	SMOKE DETECTOR
	COVE LIGHT
	EXISTING CEILING ACCESS
	WALL-MOUNTED 4' WRAP-AROUND LIGHT FIXTURE.
	CEILING MOUNTED FIRE ALARM STROBE
	MOTION SENSOR DETECTOR
	WI-FI ROUTER

FOURTH FLOOR REFLECTED CEILING PLAN


DATE	REVISIONS	REMARKS

PA / PM:	
DRAWN BY:	W. BASTRUP
JOB NO.:	SDG24-2003-00

SHEET
B123

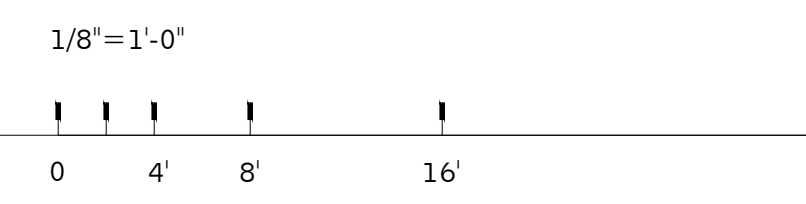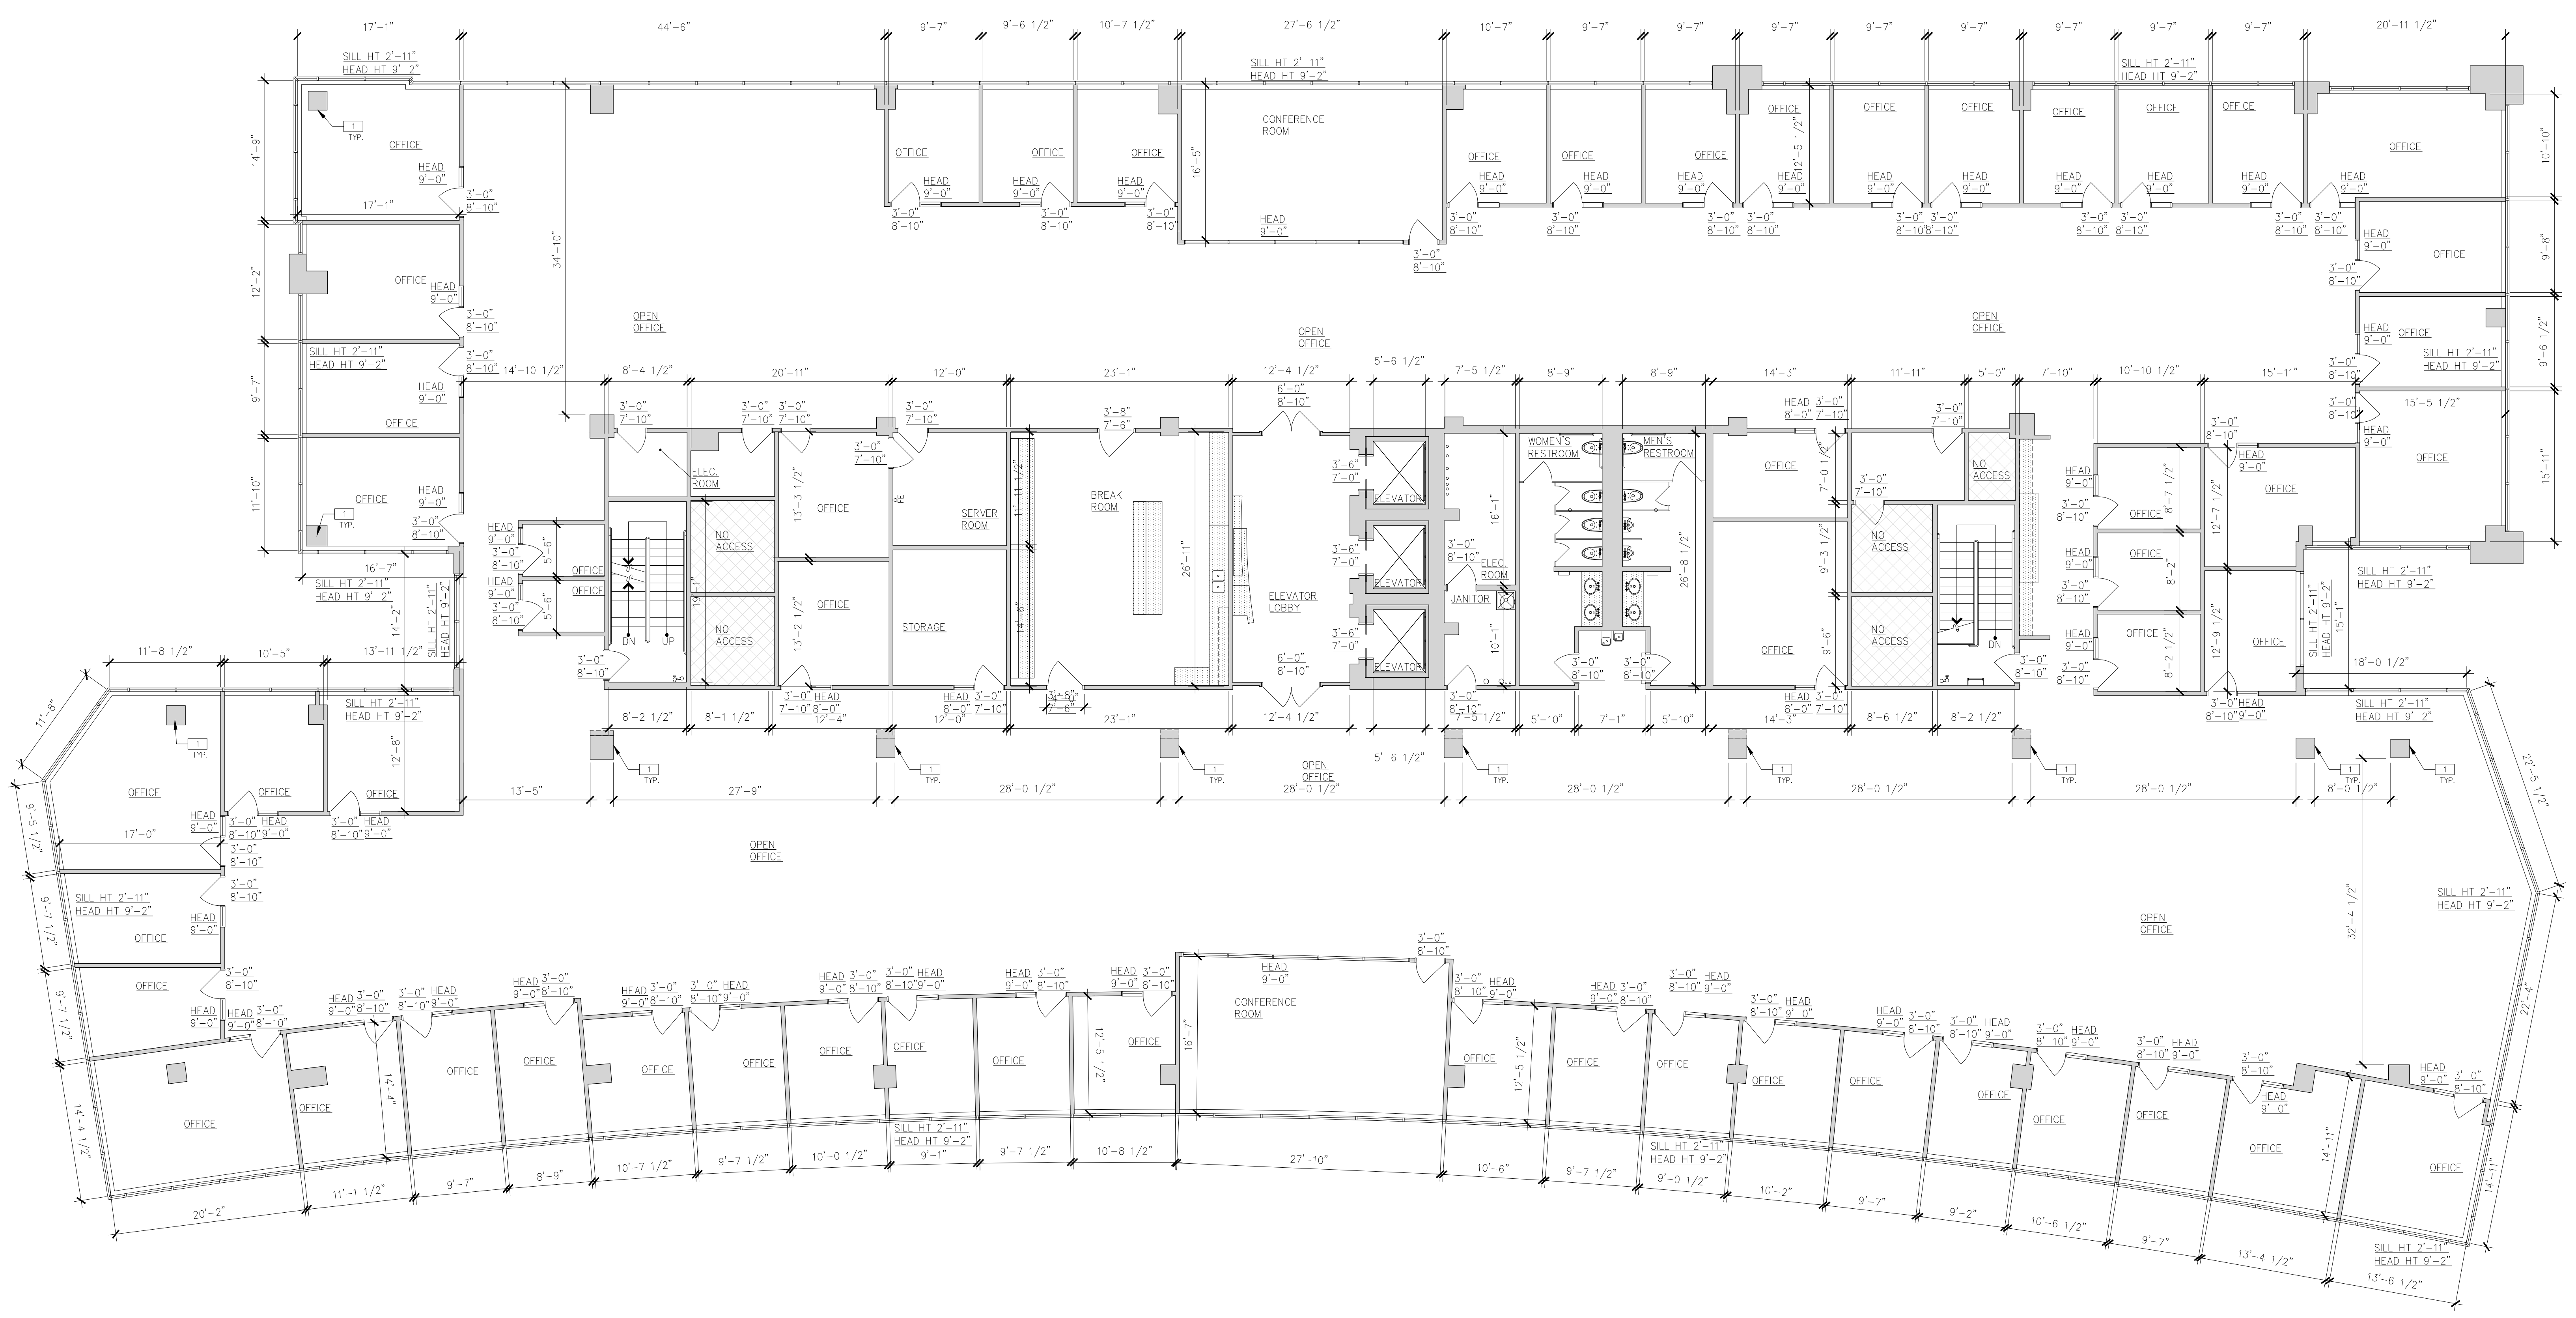

FIFTH FLOOR PLAN - DIMENSIONED

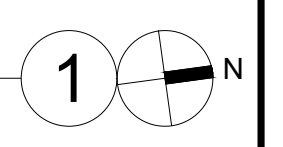

WALL LEGEND

WALL PARTITION	BASIC DESCRIPTION
	EXISTING WALL/PARTITION

LEGEND

	NOT IN SCOPE OF WORK. AREA NOT ACCESSED OR VERIFIED BY BUILDING MEASUREMENT SERVICES. WALL THICKNESSES SHOWN IN AREAS NOT VERIFIED ARE ASSUMED.
--	---

FLOOR PLAN NOTES

SEE SHEET A0.2 FOR GENERAL NOTES

	COLUMN
--	--------

KEY PLAN

architecture
planning
interiors
graphics

WARE MALCOLM

10 addham
 Irvine, California 92618
 P 949.663.5221 F 949.663.1851

Irvine
 Los Angeles
 northern california
 sacramento
 san diego
 denver
 chicago
 new jersey



FIFTH FLOOR PLAN - DIMENSIONED

DATE	REVISIONS	REMARKS

PA / PM:	
DRAWN BY:	W. BASTRUP
JOB NO.:	SD024-2003-00


SHEET

B130

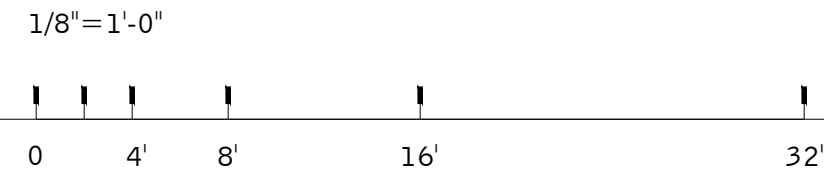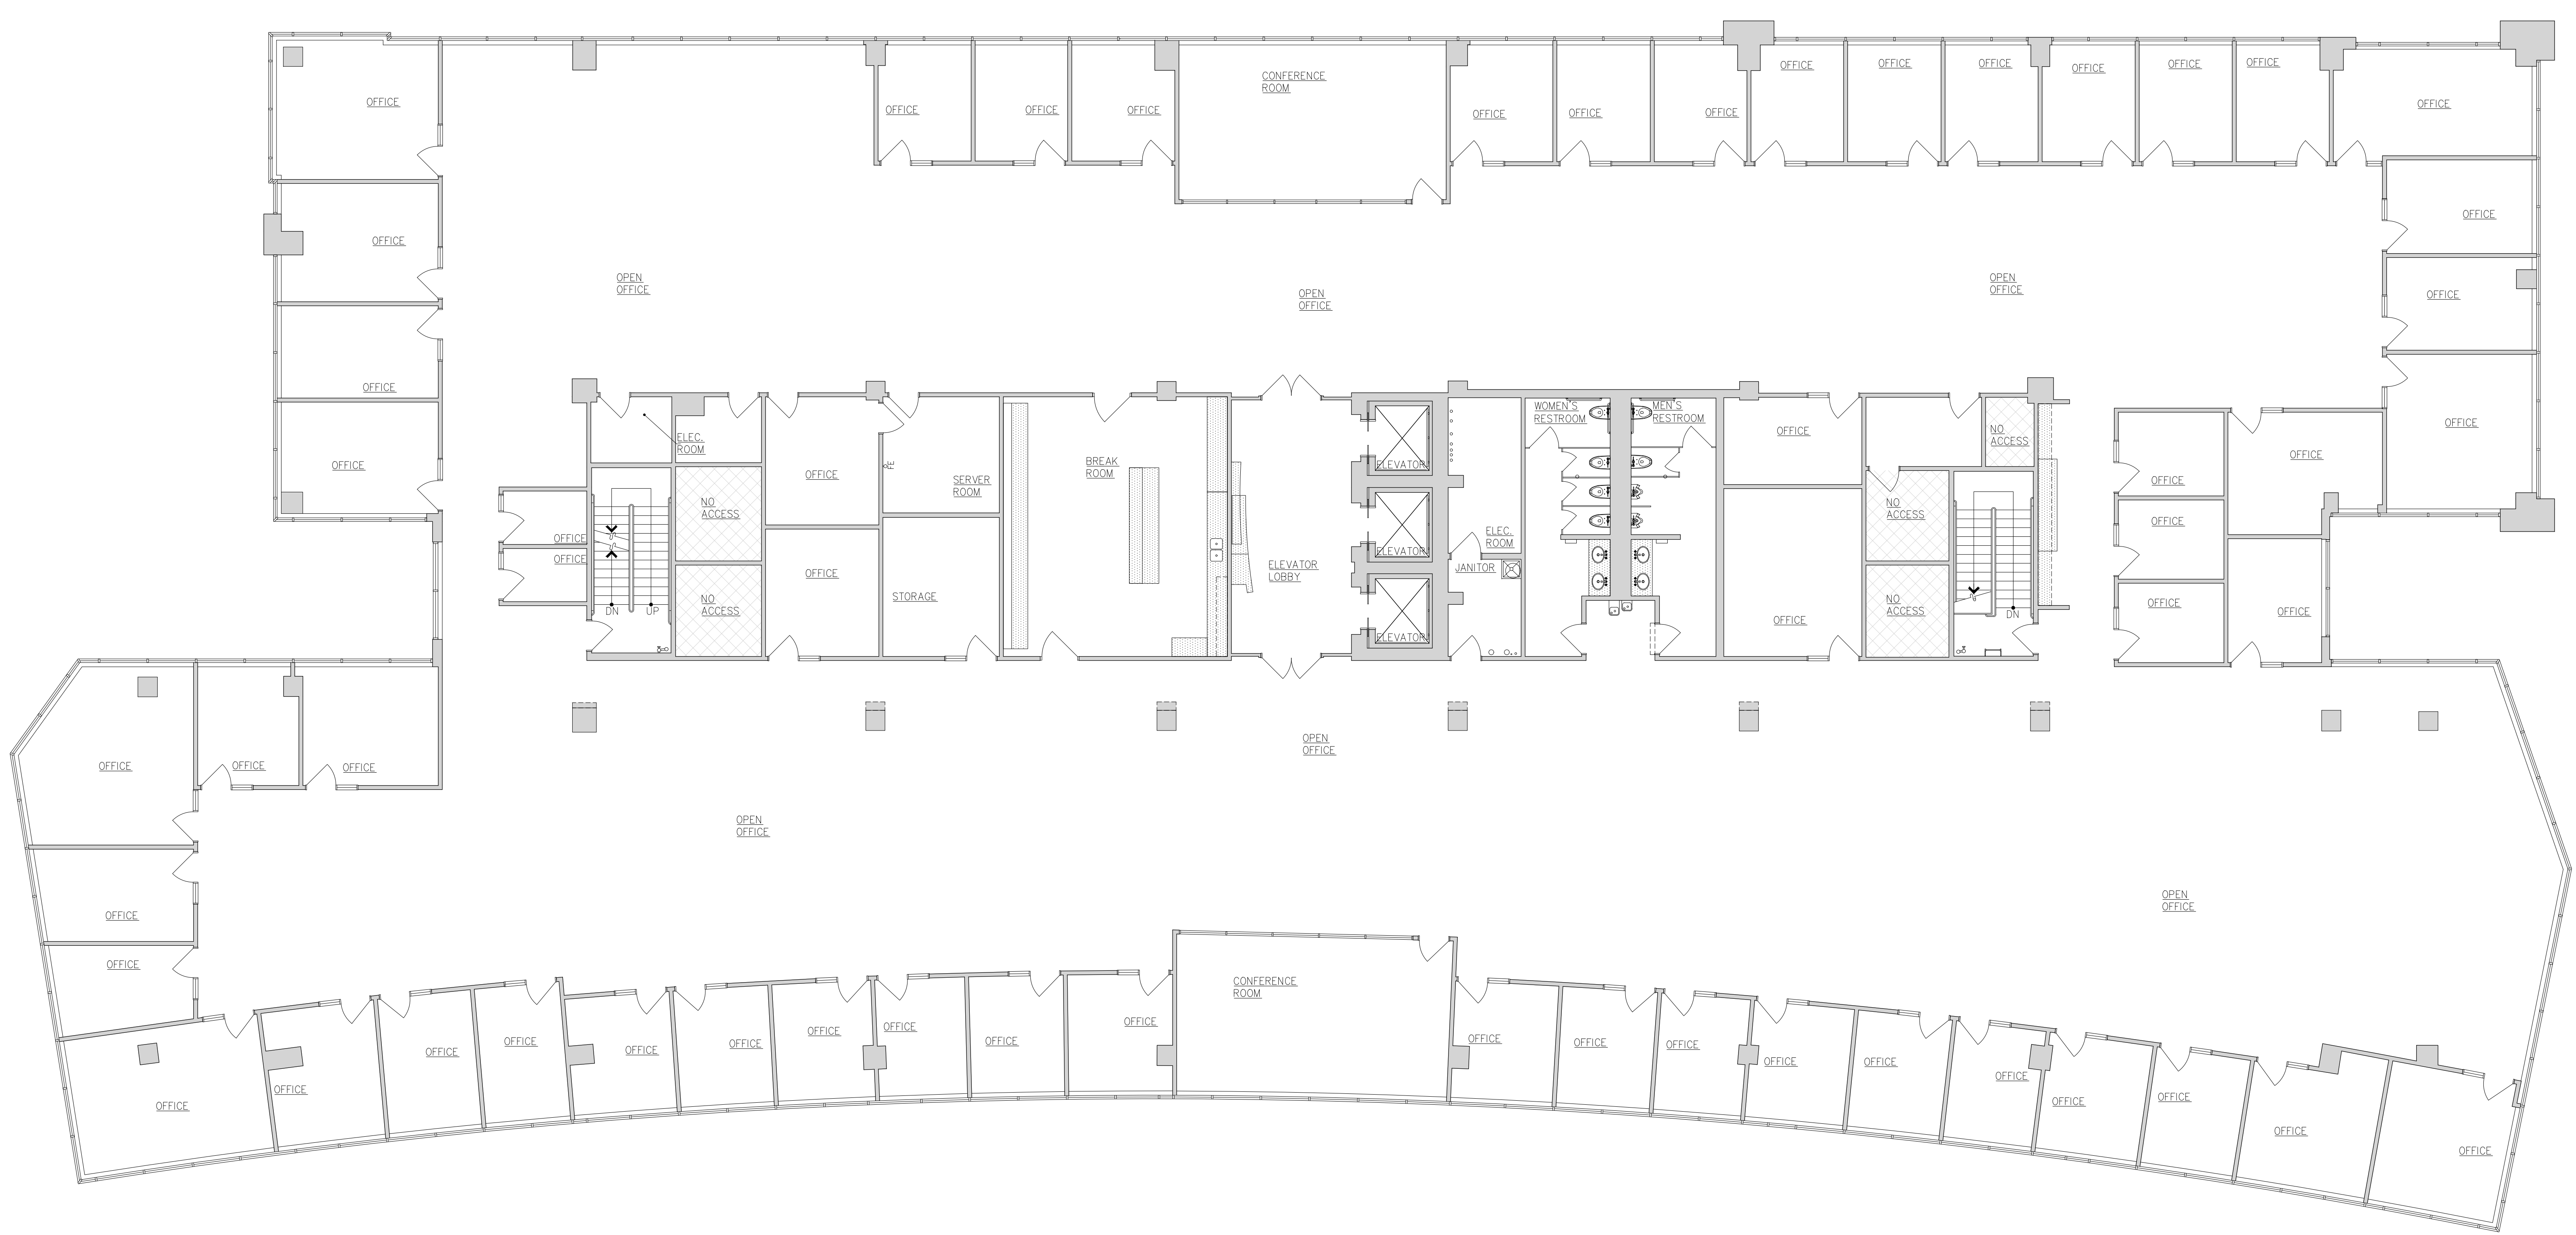

FIFTH FLOOR PLAN - NON DIMENSIONED

 1/8"=1'-0"



E:\BMS\Projects\SDC24-2003-00\OUT\2024-02-27\2003_SHEETS.dwg

THESE DRAWINGS AND SPECIFICATIONS ARE THE PROPERTY AND COPYRIGHT OF WARE MALCOLM AND SHALL NOT BE USED ON ANY OTHER WORK EXCEPT BY AGREEMENT WITH WARE MALCOLM. WRITTEN DIMENSIONS SHALL TAKE PREFERENCE OVER SCALED DIMENSIONS AND SHALL BE VERIFIED ON THE JOB SITE. ANY DISCREPANCY SHALL BE BROUGHT TO THE NOTICE OF WARE MALCOLM PRIOR TO THE COMMENCEMENT OF ANY WORK.

FIFTH FLOOR PLAN - NON DIMENSIONED	
DATE	REMARKS

PA / PM:	
DRAWN BY:	W. BASTRUP
JOB NO.:	SDC24-2003-00

SHEET
B131

architecture
planning
interiors
graphics


WARE MALCOLM

10 eddham
irvine, california 92618
P: 949.666.5720 F: 949.666.1191


irvine
los angeles
northridge, california
sacramento
san diego
denver
chicago
new jersey

ELECTRICAL PANEL SCHEDULE

1 30P5A 400AMPS 208Y/120V 3P/4W	4 FIRE PROTECTION POWER PANEL	7 30P5E 400AMPS 208Y/120V 3P/4W
2 30P5B 250AMPS 208Y/120V 3P/4W	5 3L5 250AMPS 480Y/277V 3P/4W	8 30P5F 250AMPS 208Y/120V 3P/4W
3 30P5C 125AMPS 208Y/120V 3P/4W	6 MICRO NOTHING CONTROL PANEL	9 30P5G 125AMPS 208Y/120V 3P/4W

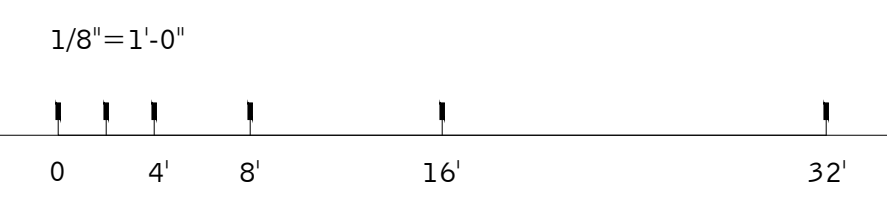

FIFTH FLOOR POWER AND SIGNAL PLAN

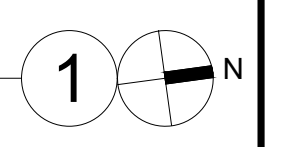

POWER & SIGNAL LEGEND

- SINGLE-PLEX RECEPTACLE
- DUPLEX RECEPTACLE
- DUPLEX RECEPTACLE, MOUNTED ABOVE COUNTER W/SWITCH
- DUPLEX RECEPTACLE, MOUNTED ABOVE COUNTER OR SPLASH
- FOURPLEX RECEPTACLE
- FOURPLEX RECEPTACLE, MOUNTED ABOVE COUNTER OR SPLASH

POWER & SIGNAL LEGEND

- TELEPHONE OUTLET MUD RING, WALL-MOUNTED
- DEDICATED DUPLEX RECEPTACLE
- DATA OUTLET MUD RING, WALL-MOUNTED
- C DAX CABLE
- COMBINATION TELEPHONE/DATA FEED, CEILING-MOUNTED
- TIMER
- C.R. WALL-MOUNTED JUNCTION BOX FOR CARD READER

POWER & SIGNAL LEGEND

- DED DEDICATED OUTLET 20AMP/250V
- FEC FIRE EXTINGUISHER CABINET
- FS FIRE STROBE
- MOTION SWITCH
- WATER LINE
- FIRE EXTINGUISHER
- THERMOSTAT

POWER & SIGNAL LEGEND

- BLANK PLATE
- CEILING-MOUNTED FIRE EXIT SIGN
- C.R. WALL-MOUNTED JUNCTION BOX FOR CARD READER
- COMBINATION DUPLEX RECEPTACLE/DATA OUTLET, MOUNTED FLUSH IN FLOOR
- EM EMERGENCY EXIT BUTTON
- HC HANDICAP BUTTON
- RELAY SWITCH
- PROJECTOR PROJECTOR SCREEN SWITCH

POWER & SIGNAL LEGEND

- AV AUDIO VISUAL PANEL
- W WIRE CHASE
- AP ALARM PANEL
- N NETWORK
- HDMI HDMI PANEL
- P VERTICAL POWER STRIP

FIFTH FLOOR POWER AND SIGNAL PLAN

DATE	REVISIONS	REMARKS



PA / PM:	
DRAWN BY:	W. BASTRUP
JOB NO.:	SDG24-2003-00

SHEET
B132


architecture
planning
interiors
graphics

WARE MALCOLM
10 eadham
irvine, california 92618
P: 949.666.5128 F: 949.666.1181

irvine
los angeles
northridge, california
sacramento
san diego
denver
chicago
new jersey

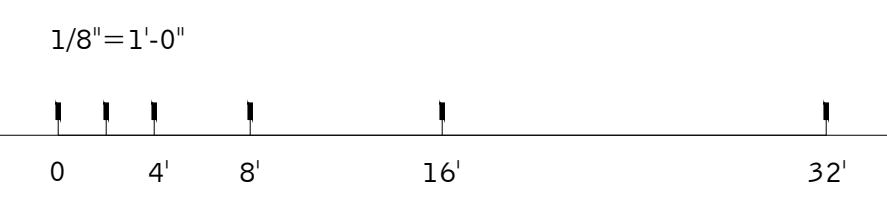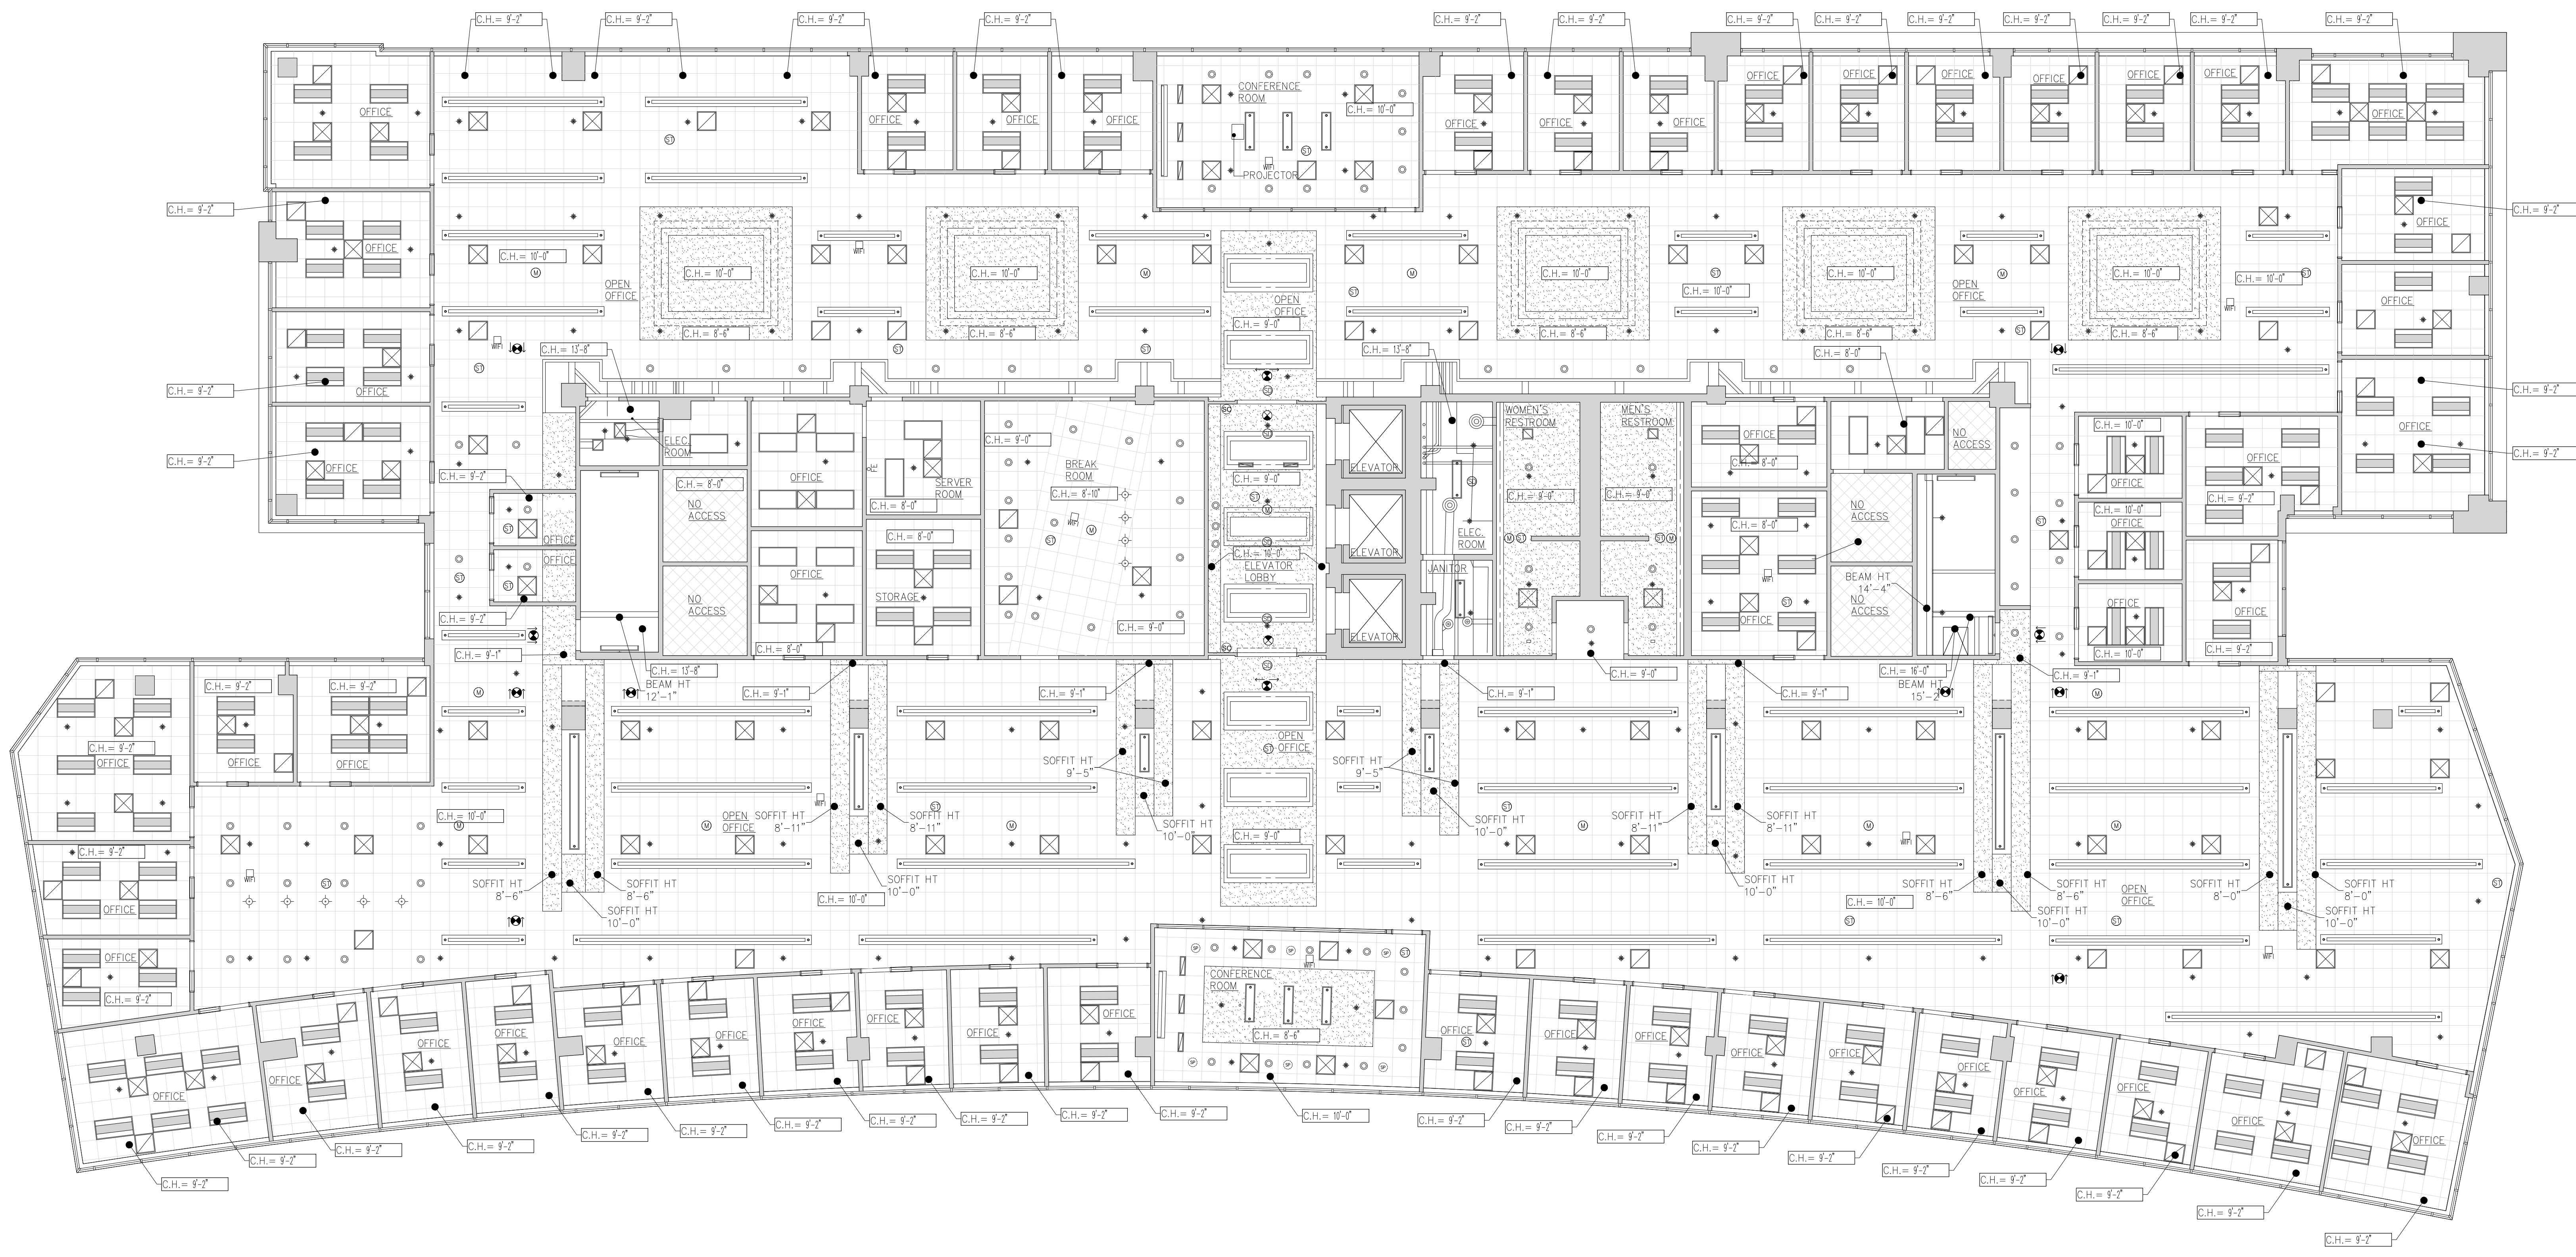

FIFTH FLOOR REFLECTED CEILING PLAN

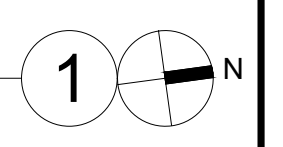

LEGEND

	EXISTING 2'x2' SUSPENDED CEILING GRID & TILES
	EXISTING 2'x4' SUSPENDED CEILING GRID & TILES
	EXISTING GYPSUM BOARD CEILING
	EXISTING SUPPLY AIR GRILL
	EXISTING RETURN AIR GRILL
	2'x4' INDIRECT LIGHT FIXTURE.

LEGEND

	2'x2' INDIRECT LIGHT FIXTURE.
	1'x4' PENDANT-HUNG LIGHT FIXTURE.
	2'x4' LIGHT FIXTURE WITH PRISMATIC LENS
	CEILING-MOUNTED EXIT SIGN
	CEILING SPRINKLER
	RECESSED CIRCULAR DOWNLIGHT.
	PENDANT-HUNG LIGHT FIXTURE.

LEGEND

	SMOKE DETECTOR
	COVE LIGHT
	EXISTING CEILING ACCESS
	WALL-MOUNTED 4' WRAP-AROUND LIGHT FIXTURE.
	CEILING MOUNTED FIRE ALARM STROBE
	MOTION SENSOR DETECTOR
	WI-FI ROUTER

FIFTH FLOOR REFLECTED CEILING PLAN

DATE	DATE	REMARKS

PA / PM:	
DRAWN BY:	W. BASTRUP
JOB NO.:	SD024-2003-00

SHEET
B133